

STUDIO HOUSE

700 SQ. FT.

JORDAN DUNNING

COVER PAGE

A1- BASEMENT FLOOR PLAN

A2- MAIN FLOOR PLAN

A3- ROOF PLAN

A4- SITE PLAN

A5- SECTION 1

A6- SECTION 2

A7- NORTH ELEVATION

A8- SOUTH ELEVATION

A9- EAST ELEVATION

A10- WEST ELEVATION



E1- BASEMENT

ELECTRICAL PLAN

E2- MAIN FLOOR

ELECTRICAL PLAN



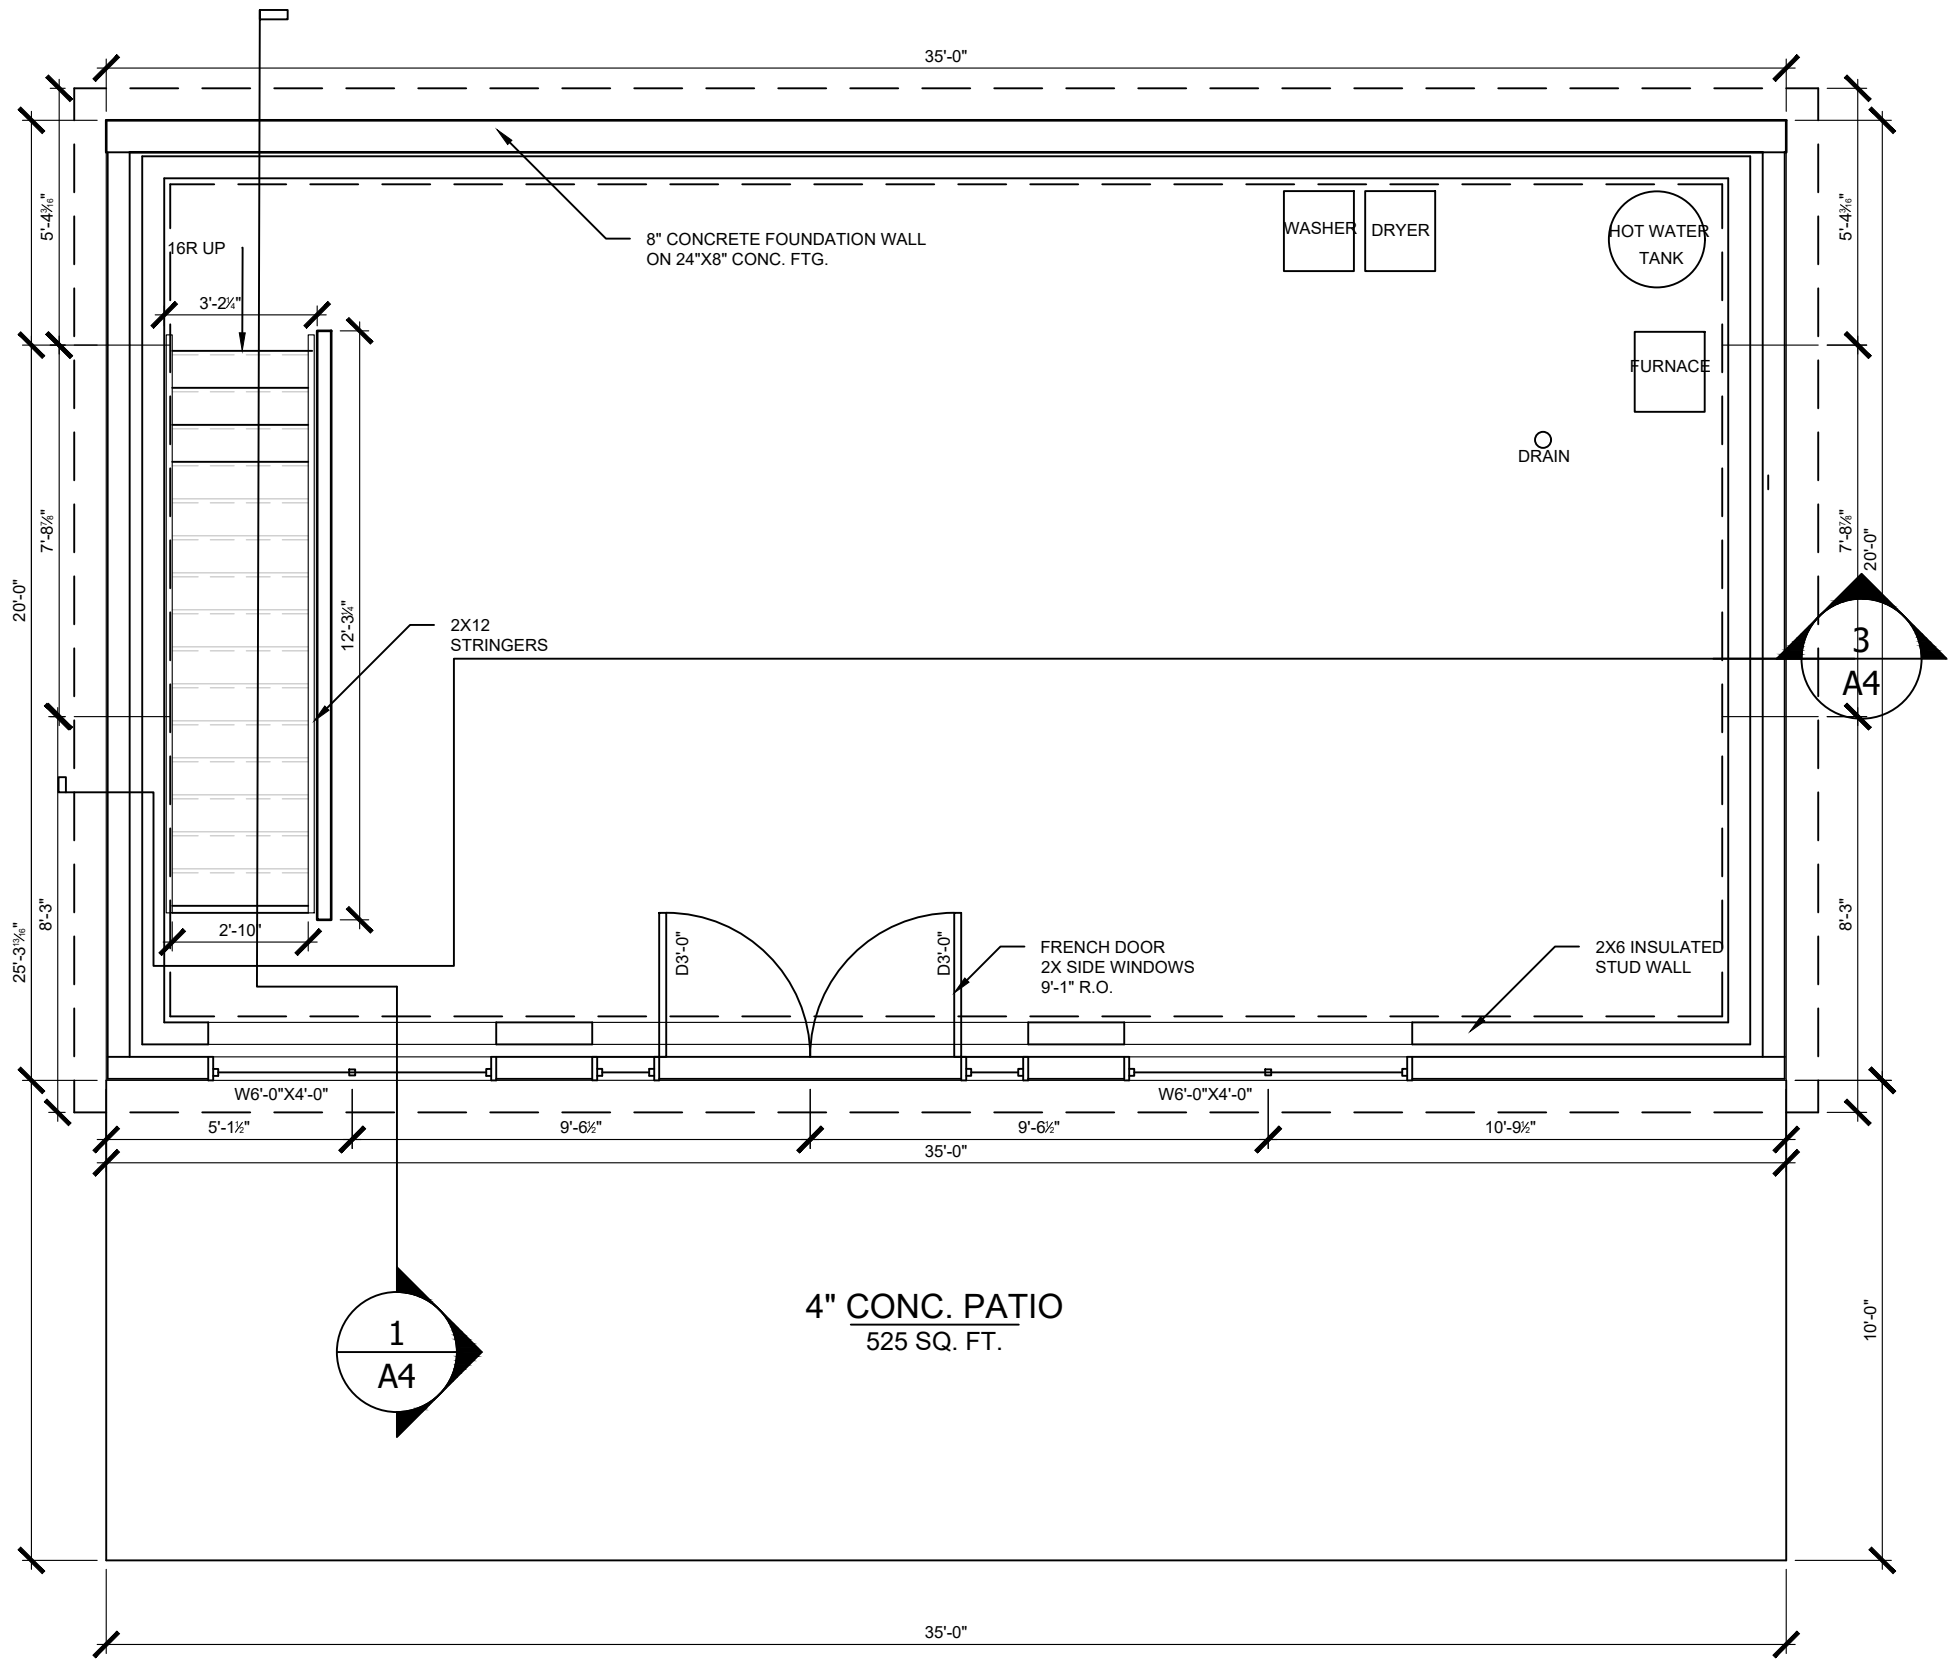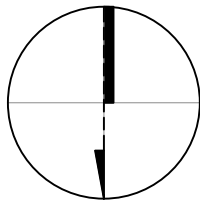

This drawing is the property of the SAIT.
The contractor shall check and verify all
dimensions and report any discrepancies
to the designers prior to construction.
Do not scale drawing.
This drawing is not to be used for
construction unless it has been signed
and approved.

Revisions:

Issued For:

Consultants/Seals:

Project:
STUDIO HOUSE
PROJECT
ASSIGNMENT 9

Drawing Name:
FOUNDATION
FLOOR PLAN

Drawn: JD Checked: LS



Date: 2018/04/19

Drawing Scale: 1/4"=1'0"

Project Number: Sheet:

215-9 A1 OF 09

File Number: J DUNNING

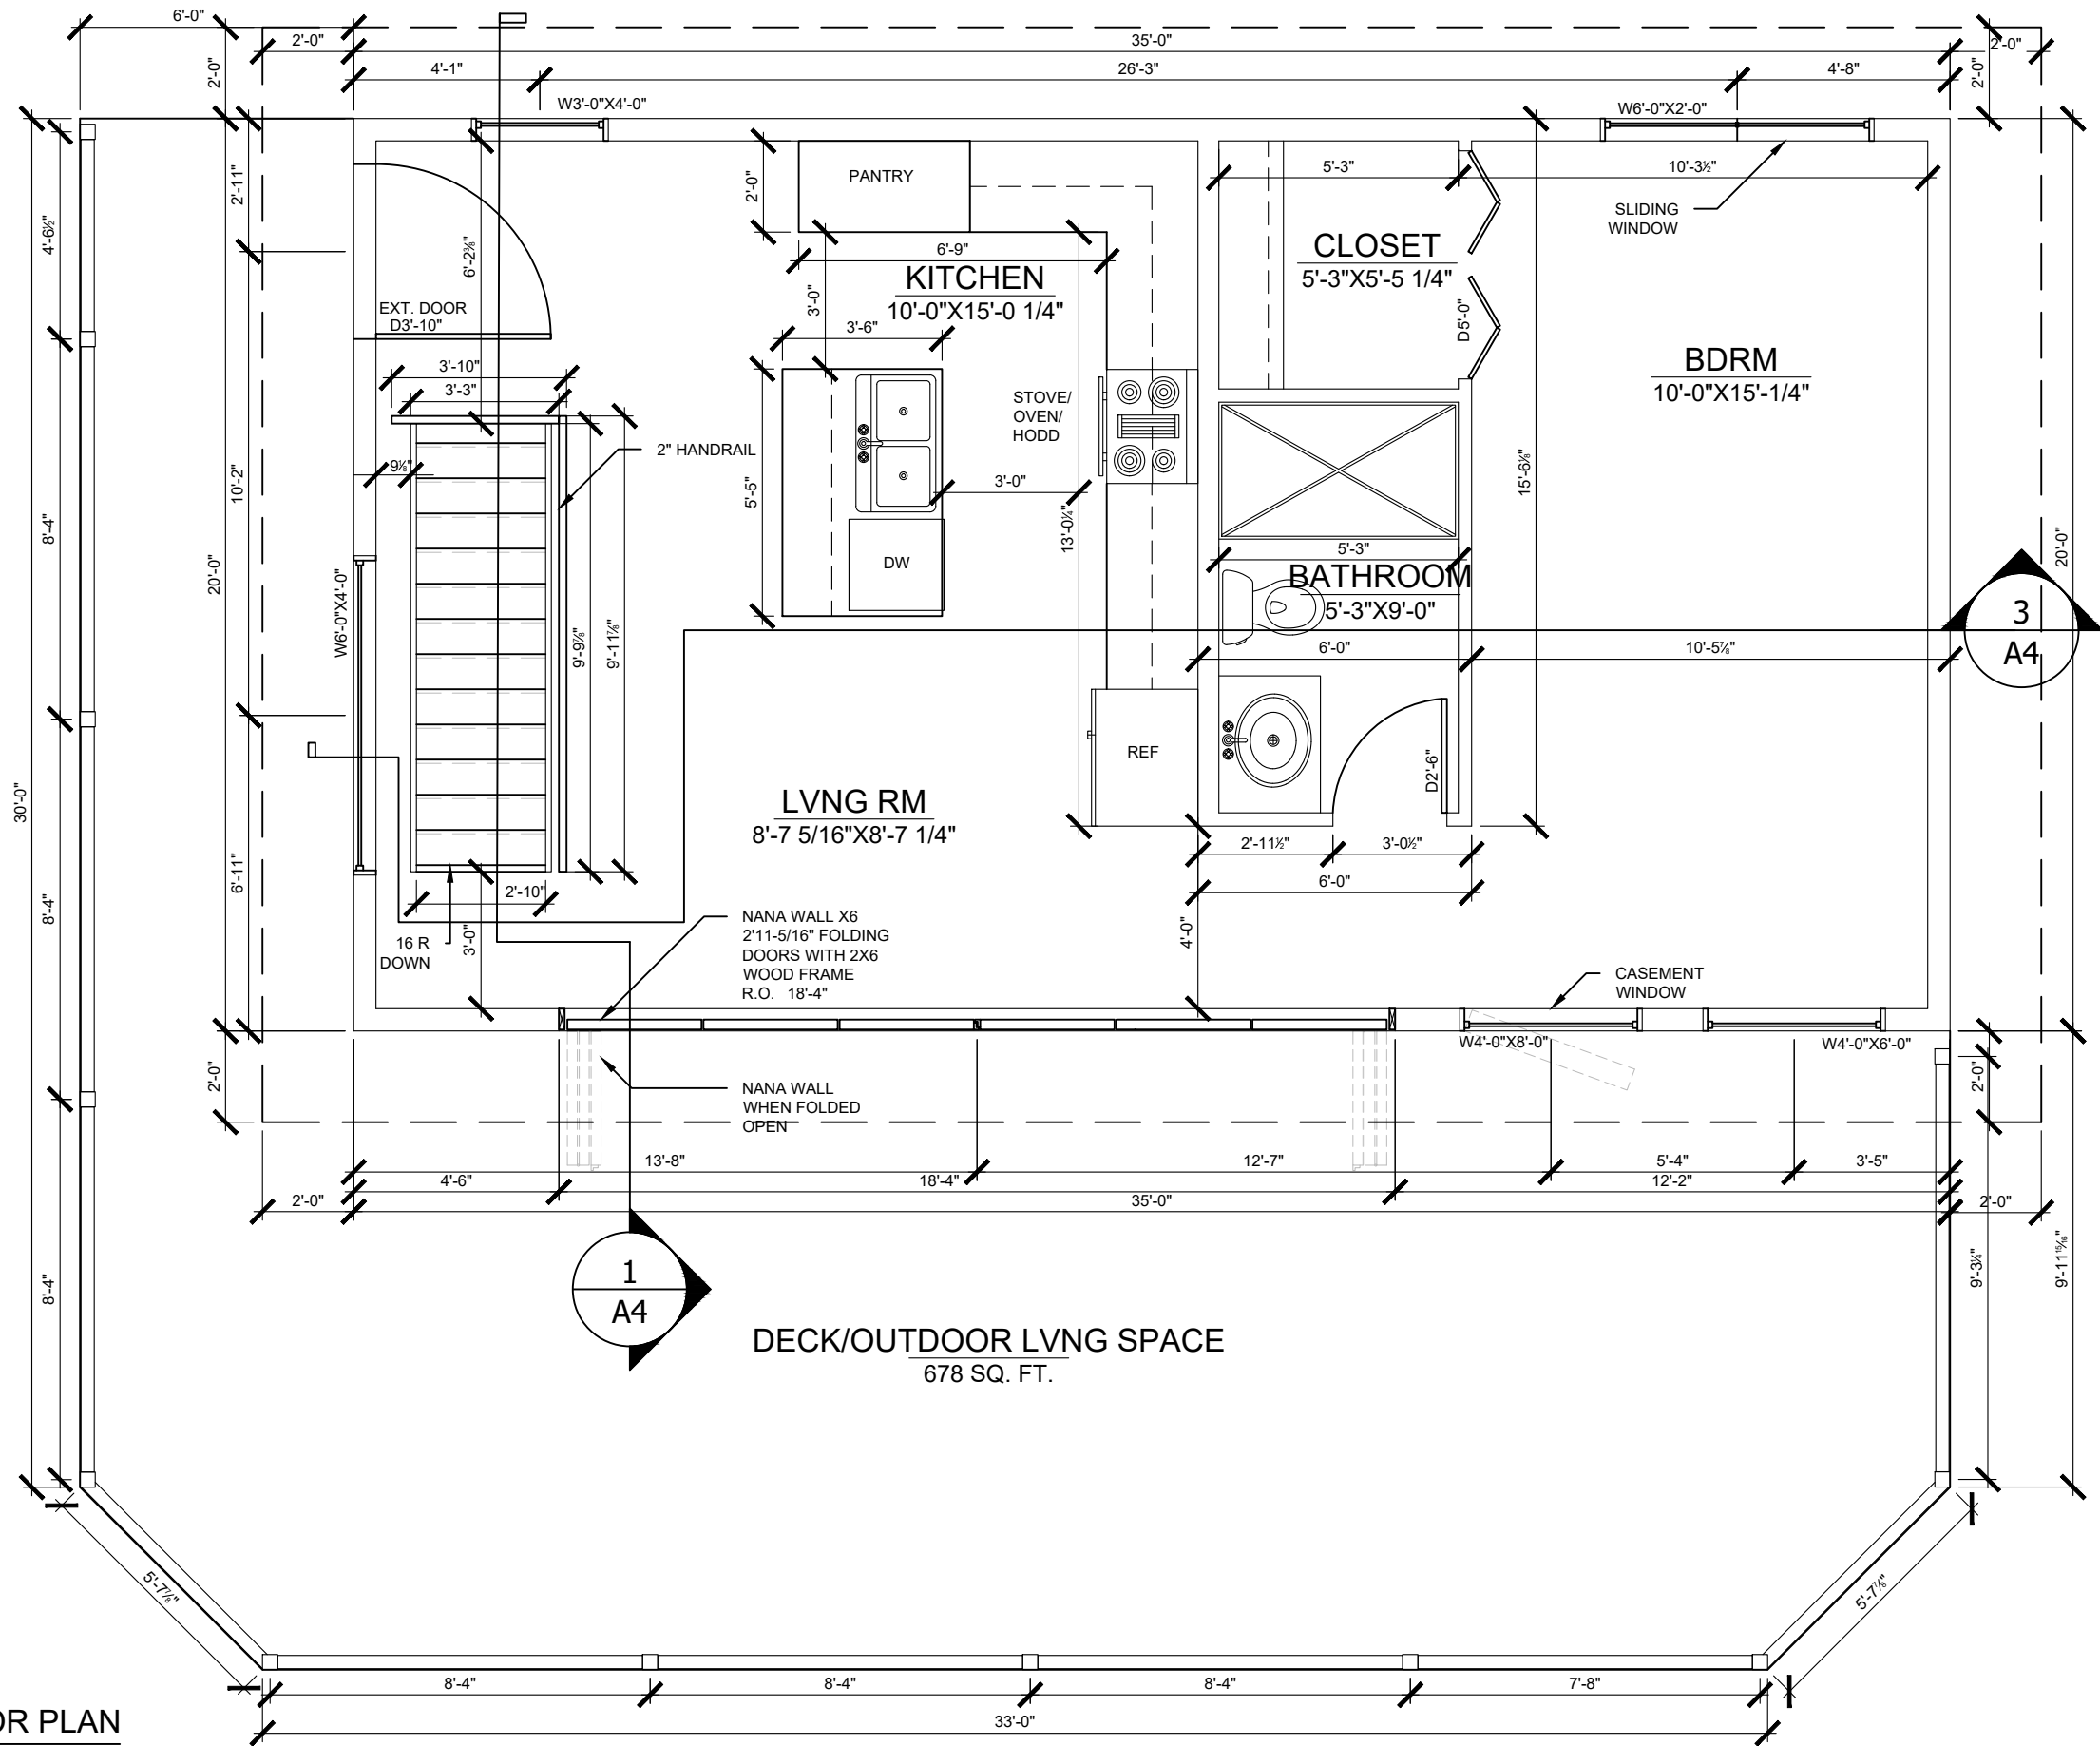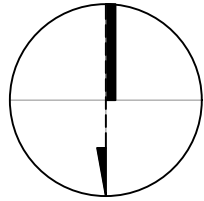

1
A2

MAINFLOOR FLOOR PLAN

SCALE 1/4" = 1'-0"

JD

This drawing is the property of the SAIT.
The contractor shall check and verify all
dimensions and report any discrepancies
to the designers prior to construction.
Do not scale drawing.
This drawing is not to be used for
construction unless it has been signed
and approved.

Revisions:

Issued For:

Consultants/Seals:

Project:
STUDIO HOUSE
PROJECT
ASSIGNMENT 9

Drawing Name:
MAINFLOOR
FLOOR PLAN

Drawn: JD Checked: LS



Date: 2018/04/19

Drawing Scale: 1/4"=1'0"

Project Number: Sheet:

215-9 A2 OF 09

File Number: J DUNNING

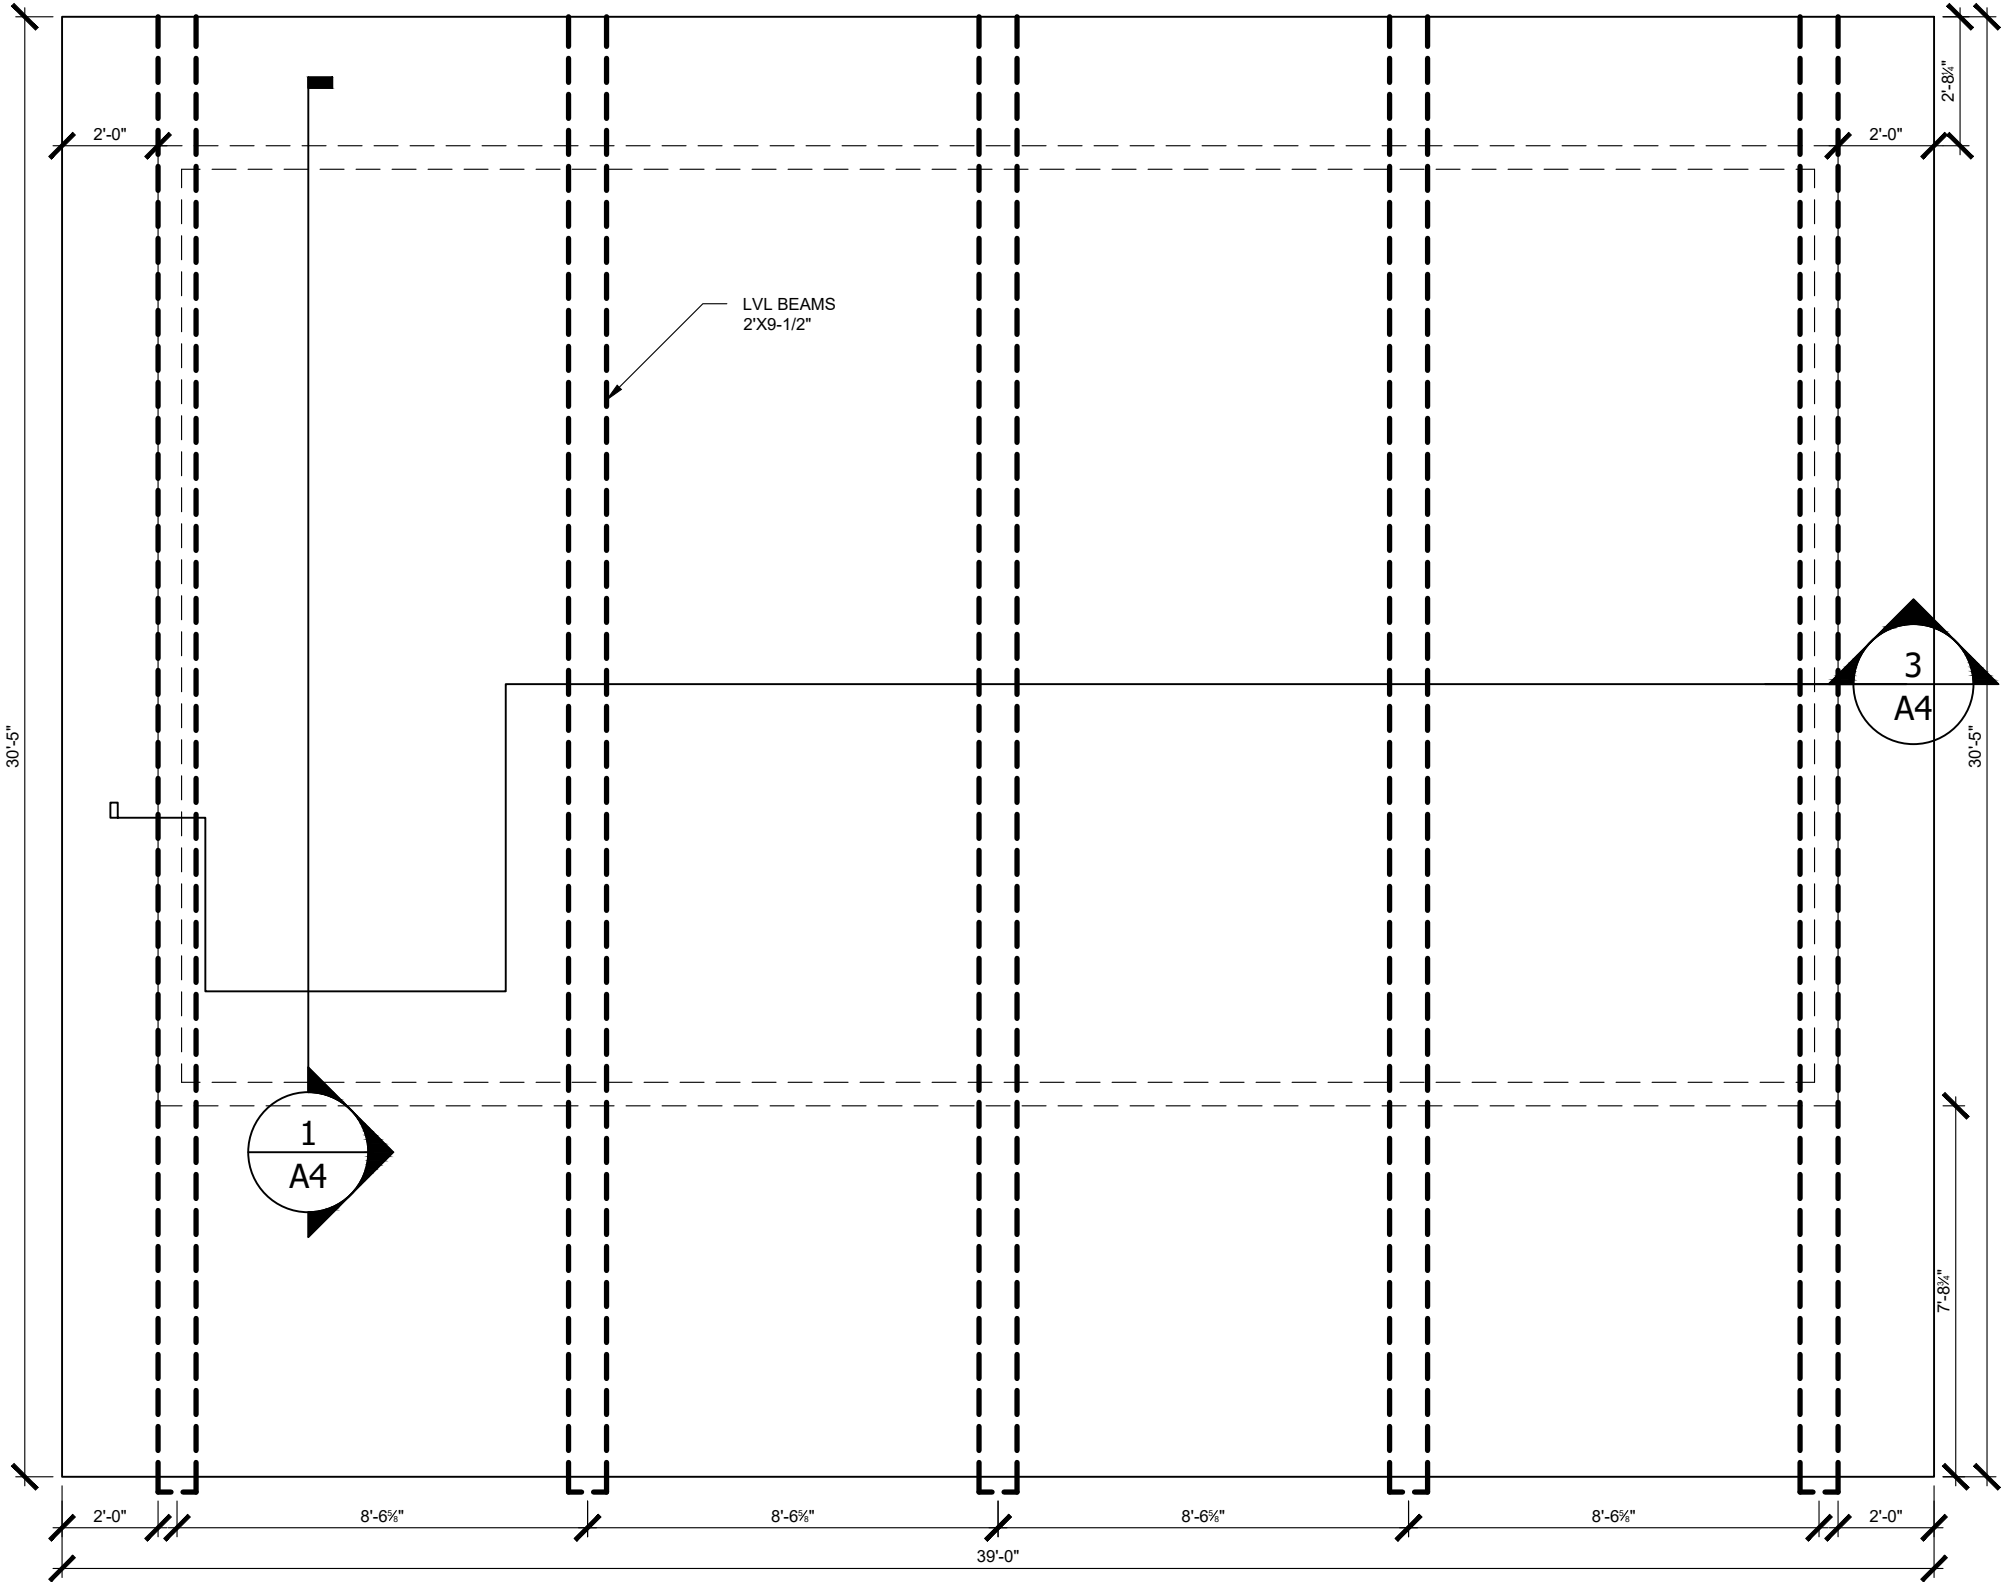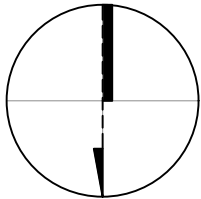

1 ROOF PLAN
A3 SCALE 1/4" = 1'-0" JD

This drawing is the property of the SAIT.
The contractor shall check and verify all
dimensions and report any discrepancies
to the designers prior to construction.
Do not scale drawing.
This drawing is not to be used for
construction unless it has been signed
and approved.

Revisions:

Issued For:

Consultants/Seals:

Project:
STUDIO HOUSE
PROJECT
ASSIGNMENT 9

Drawing Name:
ROOF PLAN

Drawn: JD Checked: LS



Date: 2018/04/19

Drawing Scale: 1/4"=1'0"

Project Number: Sheet:

215-9 A3 OF 09

File Number: J DUNNING

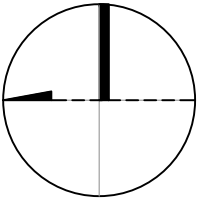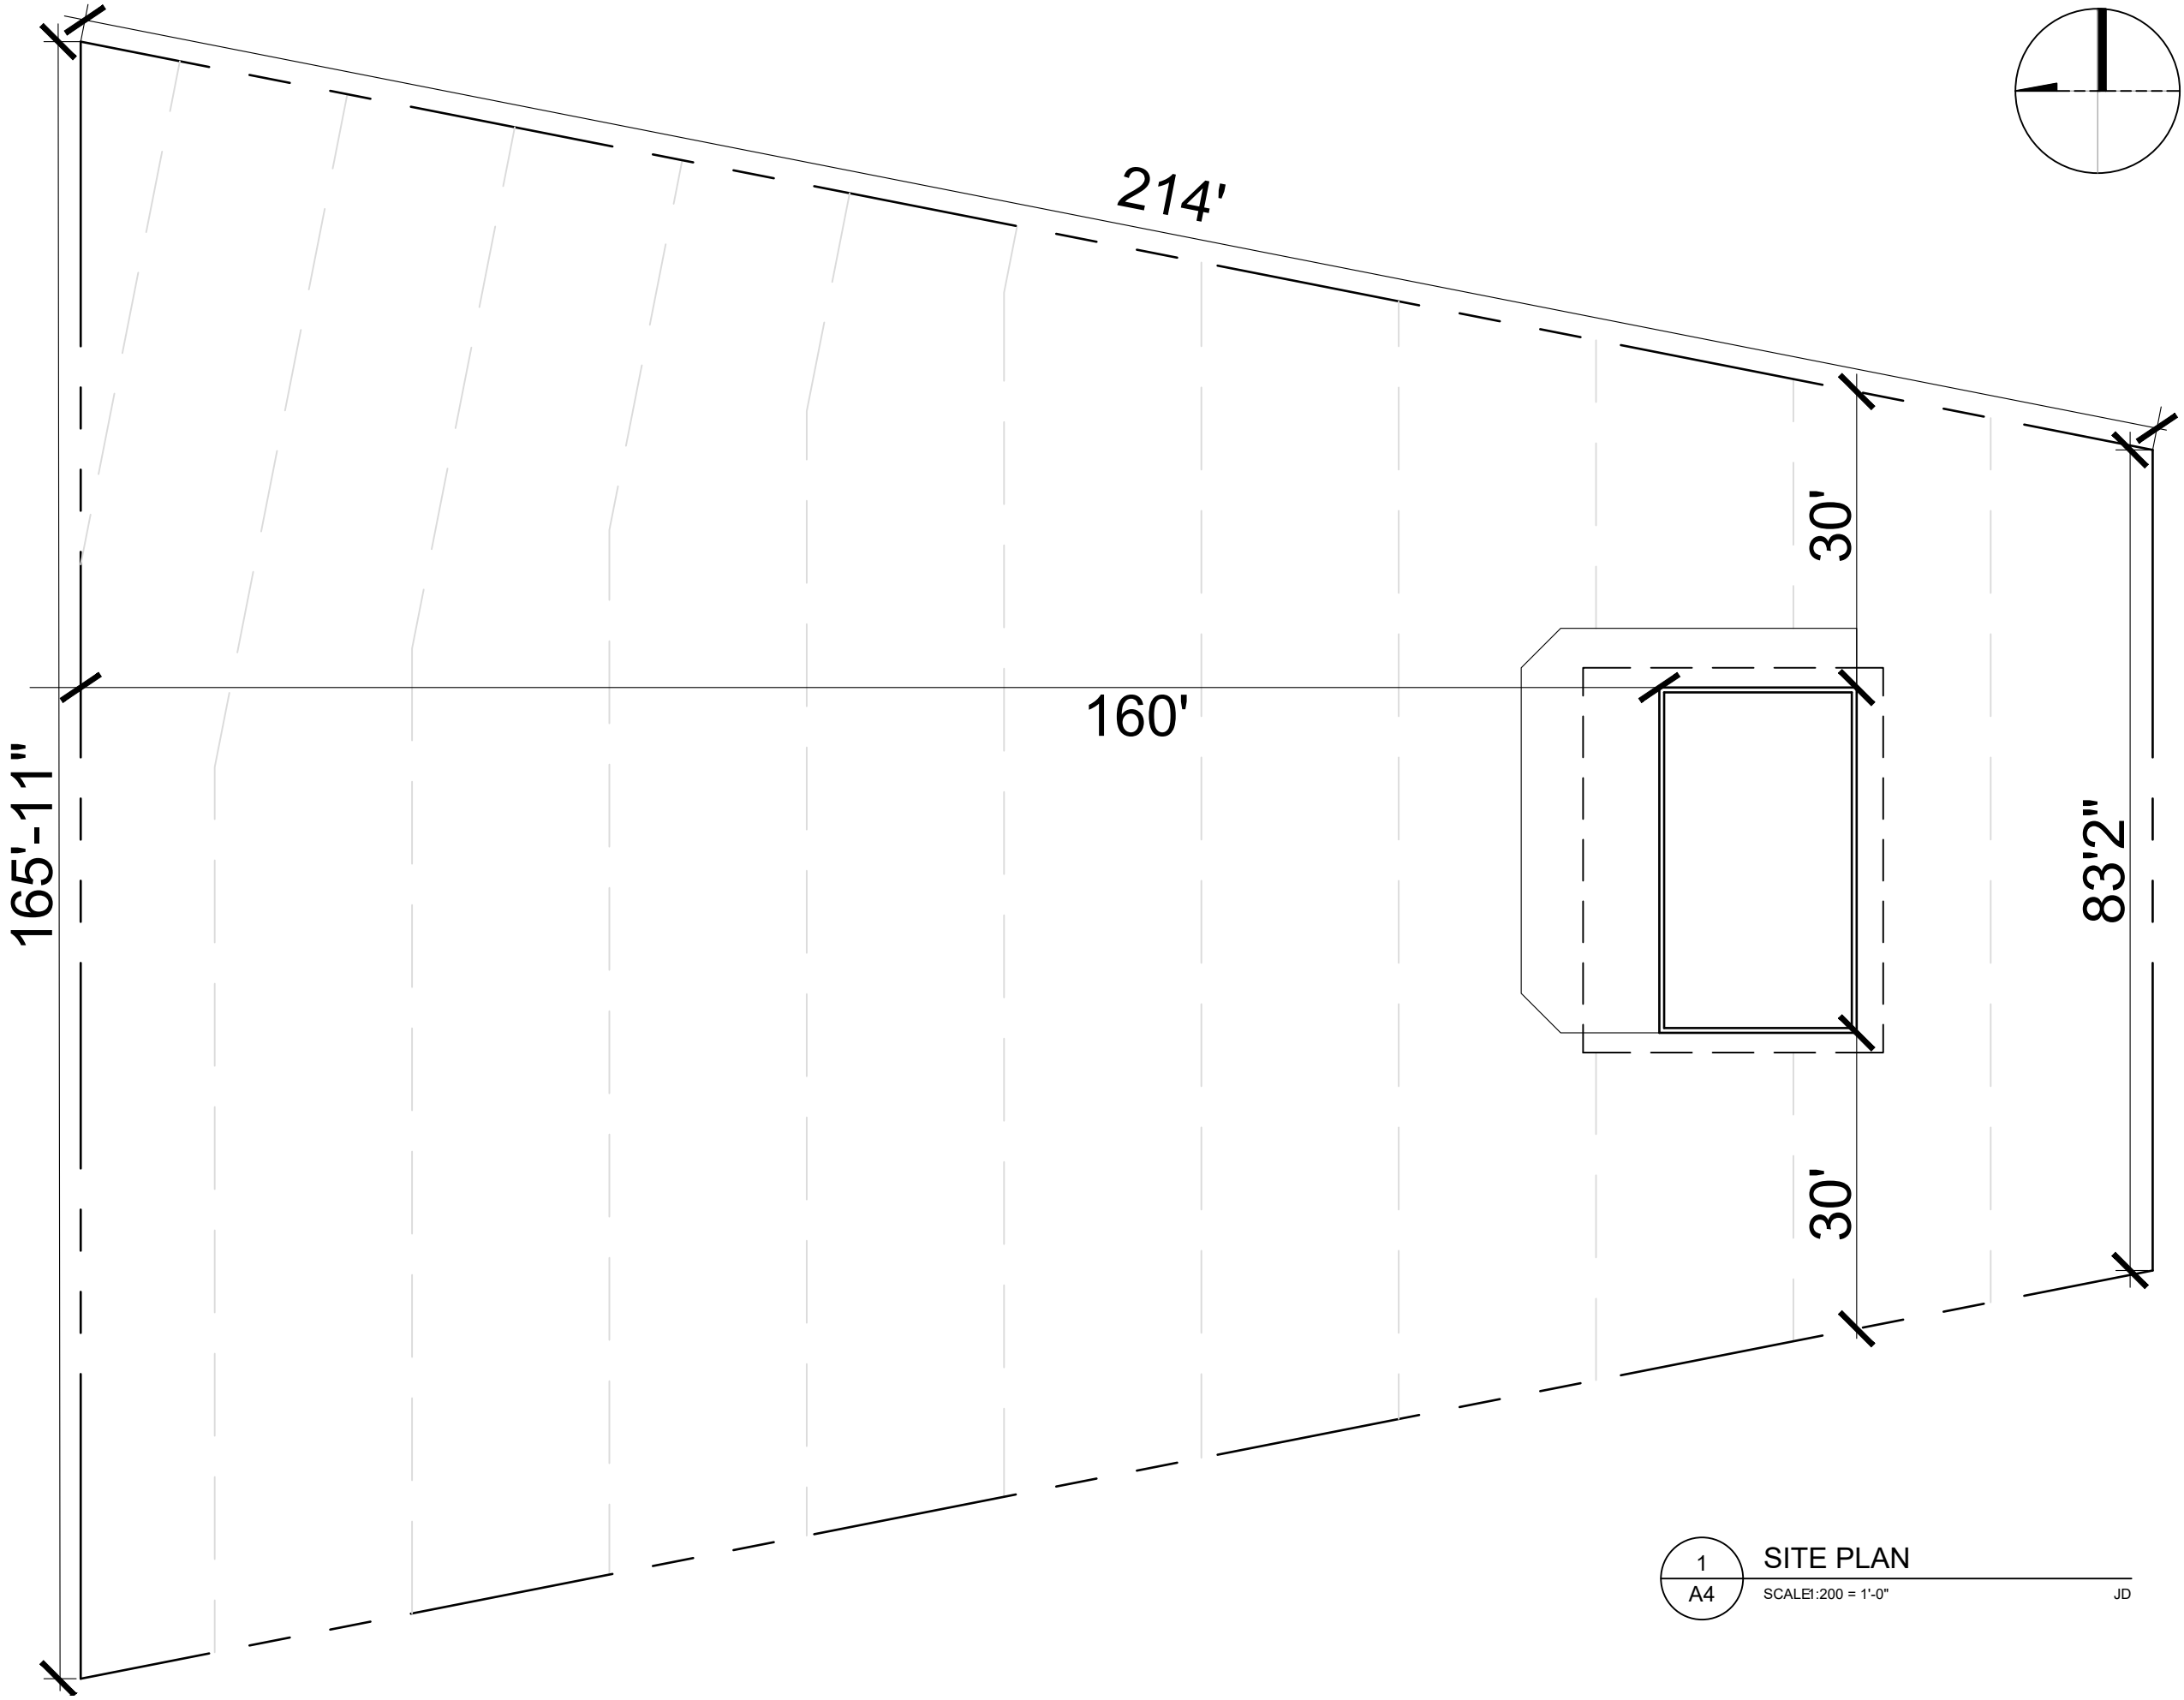

This drawing is the property of the SAIT.
The contractor shall check and verify all
dimensions and report any discrepancies
to the designers prior to construction.
Do not scale drawing.
This drawing is not to be used for
construction unless it has been signed
and approved.

Revisions:

Issued For:

Consultants/Seals:

Project:
STUDIO HOUSE
PROJECT
ASSIGNMENT 9

Drawing Name:
SITE PLAN

Drawn: JD Checked: LS

 
Date: 2018/04/19

Drawing Scale: 1:200

Project Number: Sheet:

215-9 A4 OF 09

File Number: J DUNNING



SITE PLAN

SCALE: 1:200 = 1'-0"

JD

This drawing is the property of the SAIT.
The contractor shall check and verify all
dimensions and report any discrepancies
to the designers prior to construction.
Do not scale drawing.
This drawing is not to be used for
construction unless it has been signed
and approved.

Revisions:

Issued For:

Consultants/Seals:


Project:
**STUDIO HOUSE
PROJECT
ASSIGNMENT 9**

Drawing Name:
SECTION 1

Drawn: JD Checked: LS
Date: 2018/04/19
Drawing Scale: 1/4"=1'0"

Project Number: Sheet:
215-8 A5 OF 09

File Number: J DUNNING

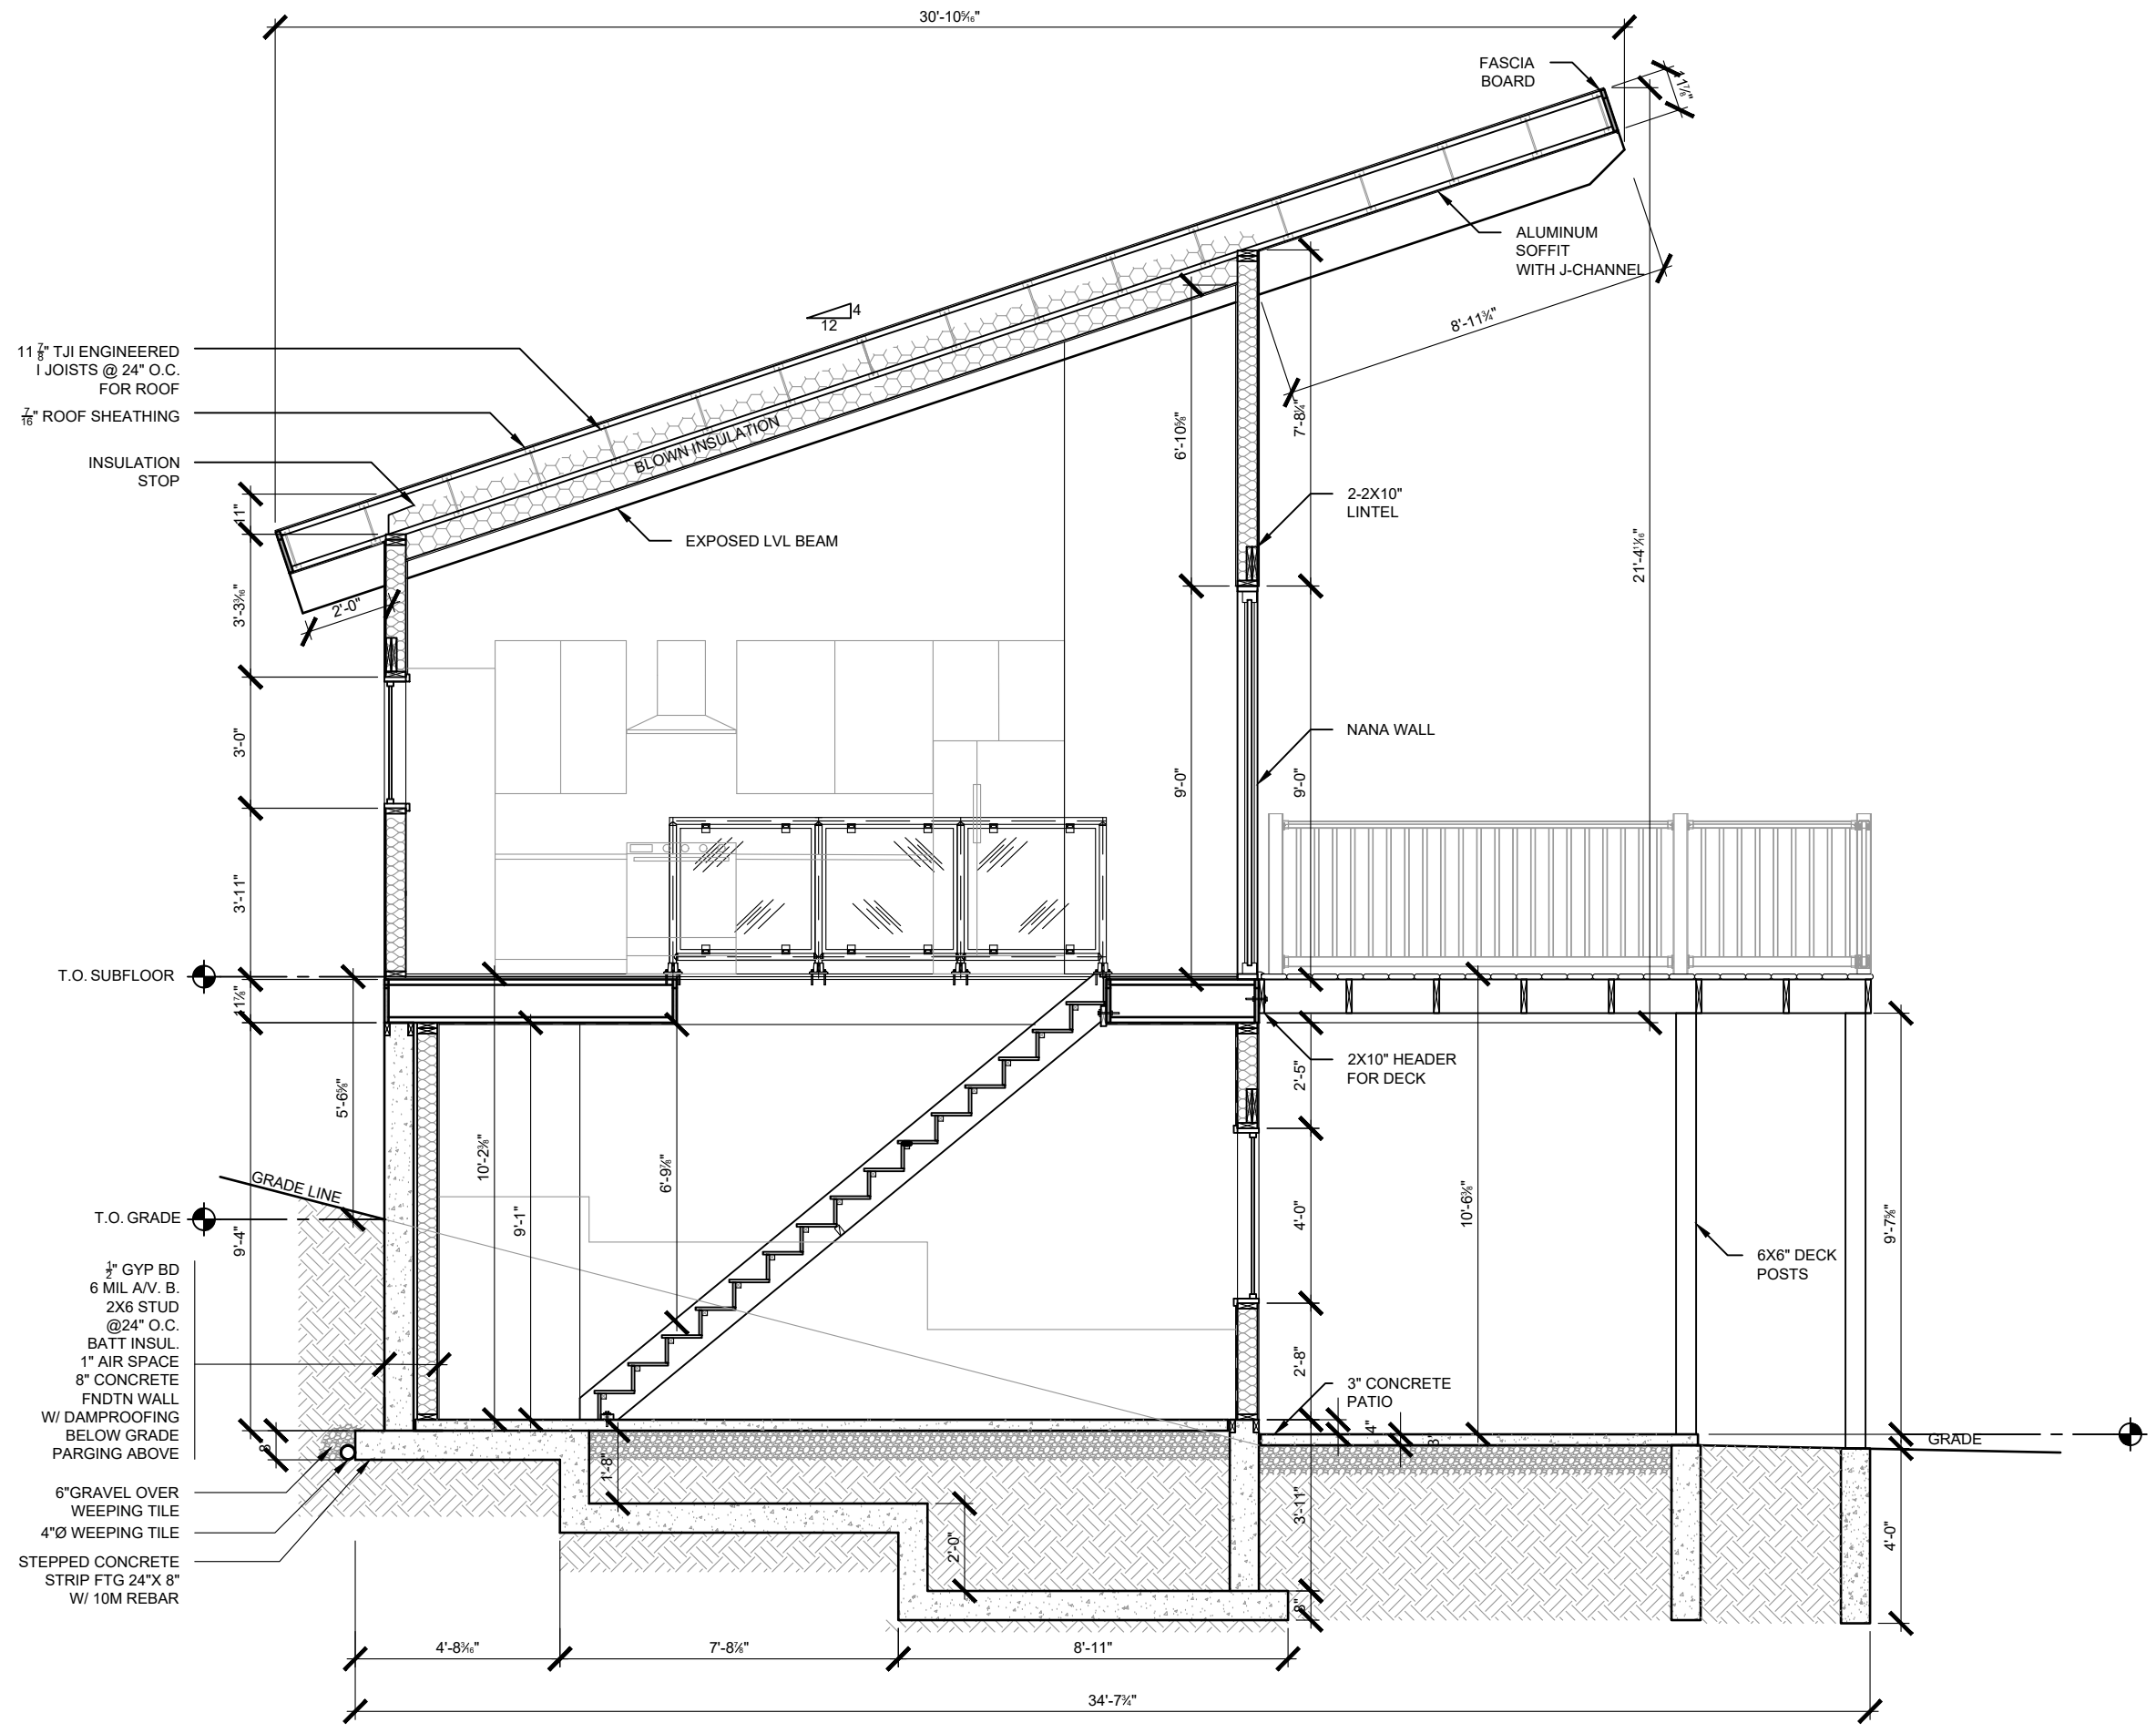

This drawing is the property of the SAIT.
The contractor shall check and verify all
dimensions and report any discrepancies
to the designers prior to construction.
Do not scale drawing.
This drawing is not to be used for
construction unless it has been signed
and approved.

Revisions:

Issued For:

Consultants/Seals:

Project:
**STUDIO HOUSE
PROJECT
ASSIGNMENT 9**

Drawing Name:
SECTION 2

Drawn: JD Checked: LS


Date: 2018/04/19

Drawing Scale: 1/4"=1'0"

Project Number: Sheet:

215-8 A6 OF 09

File Number: J DUNNING

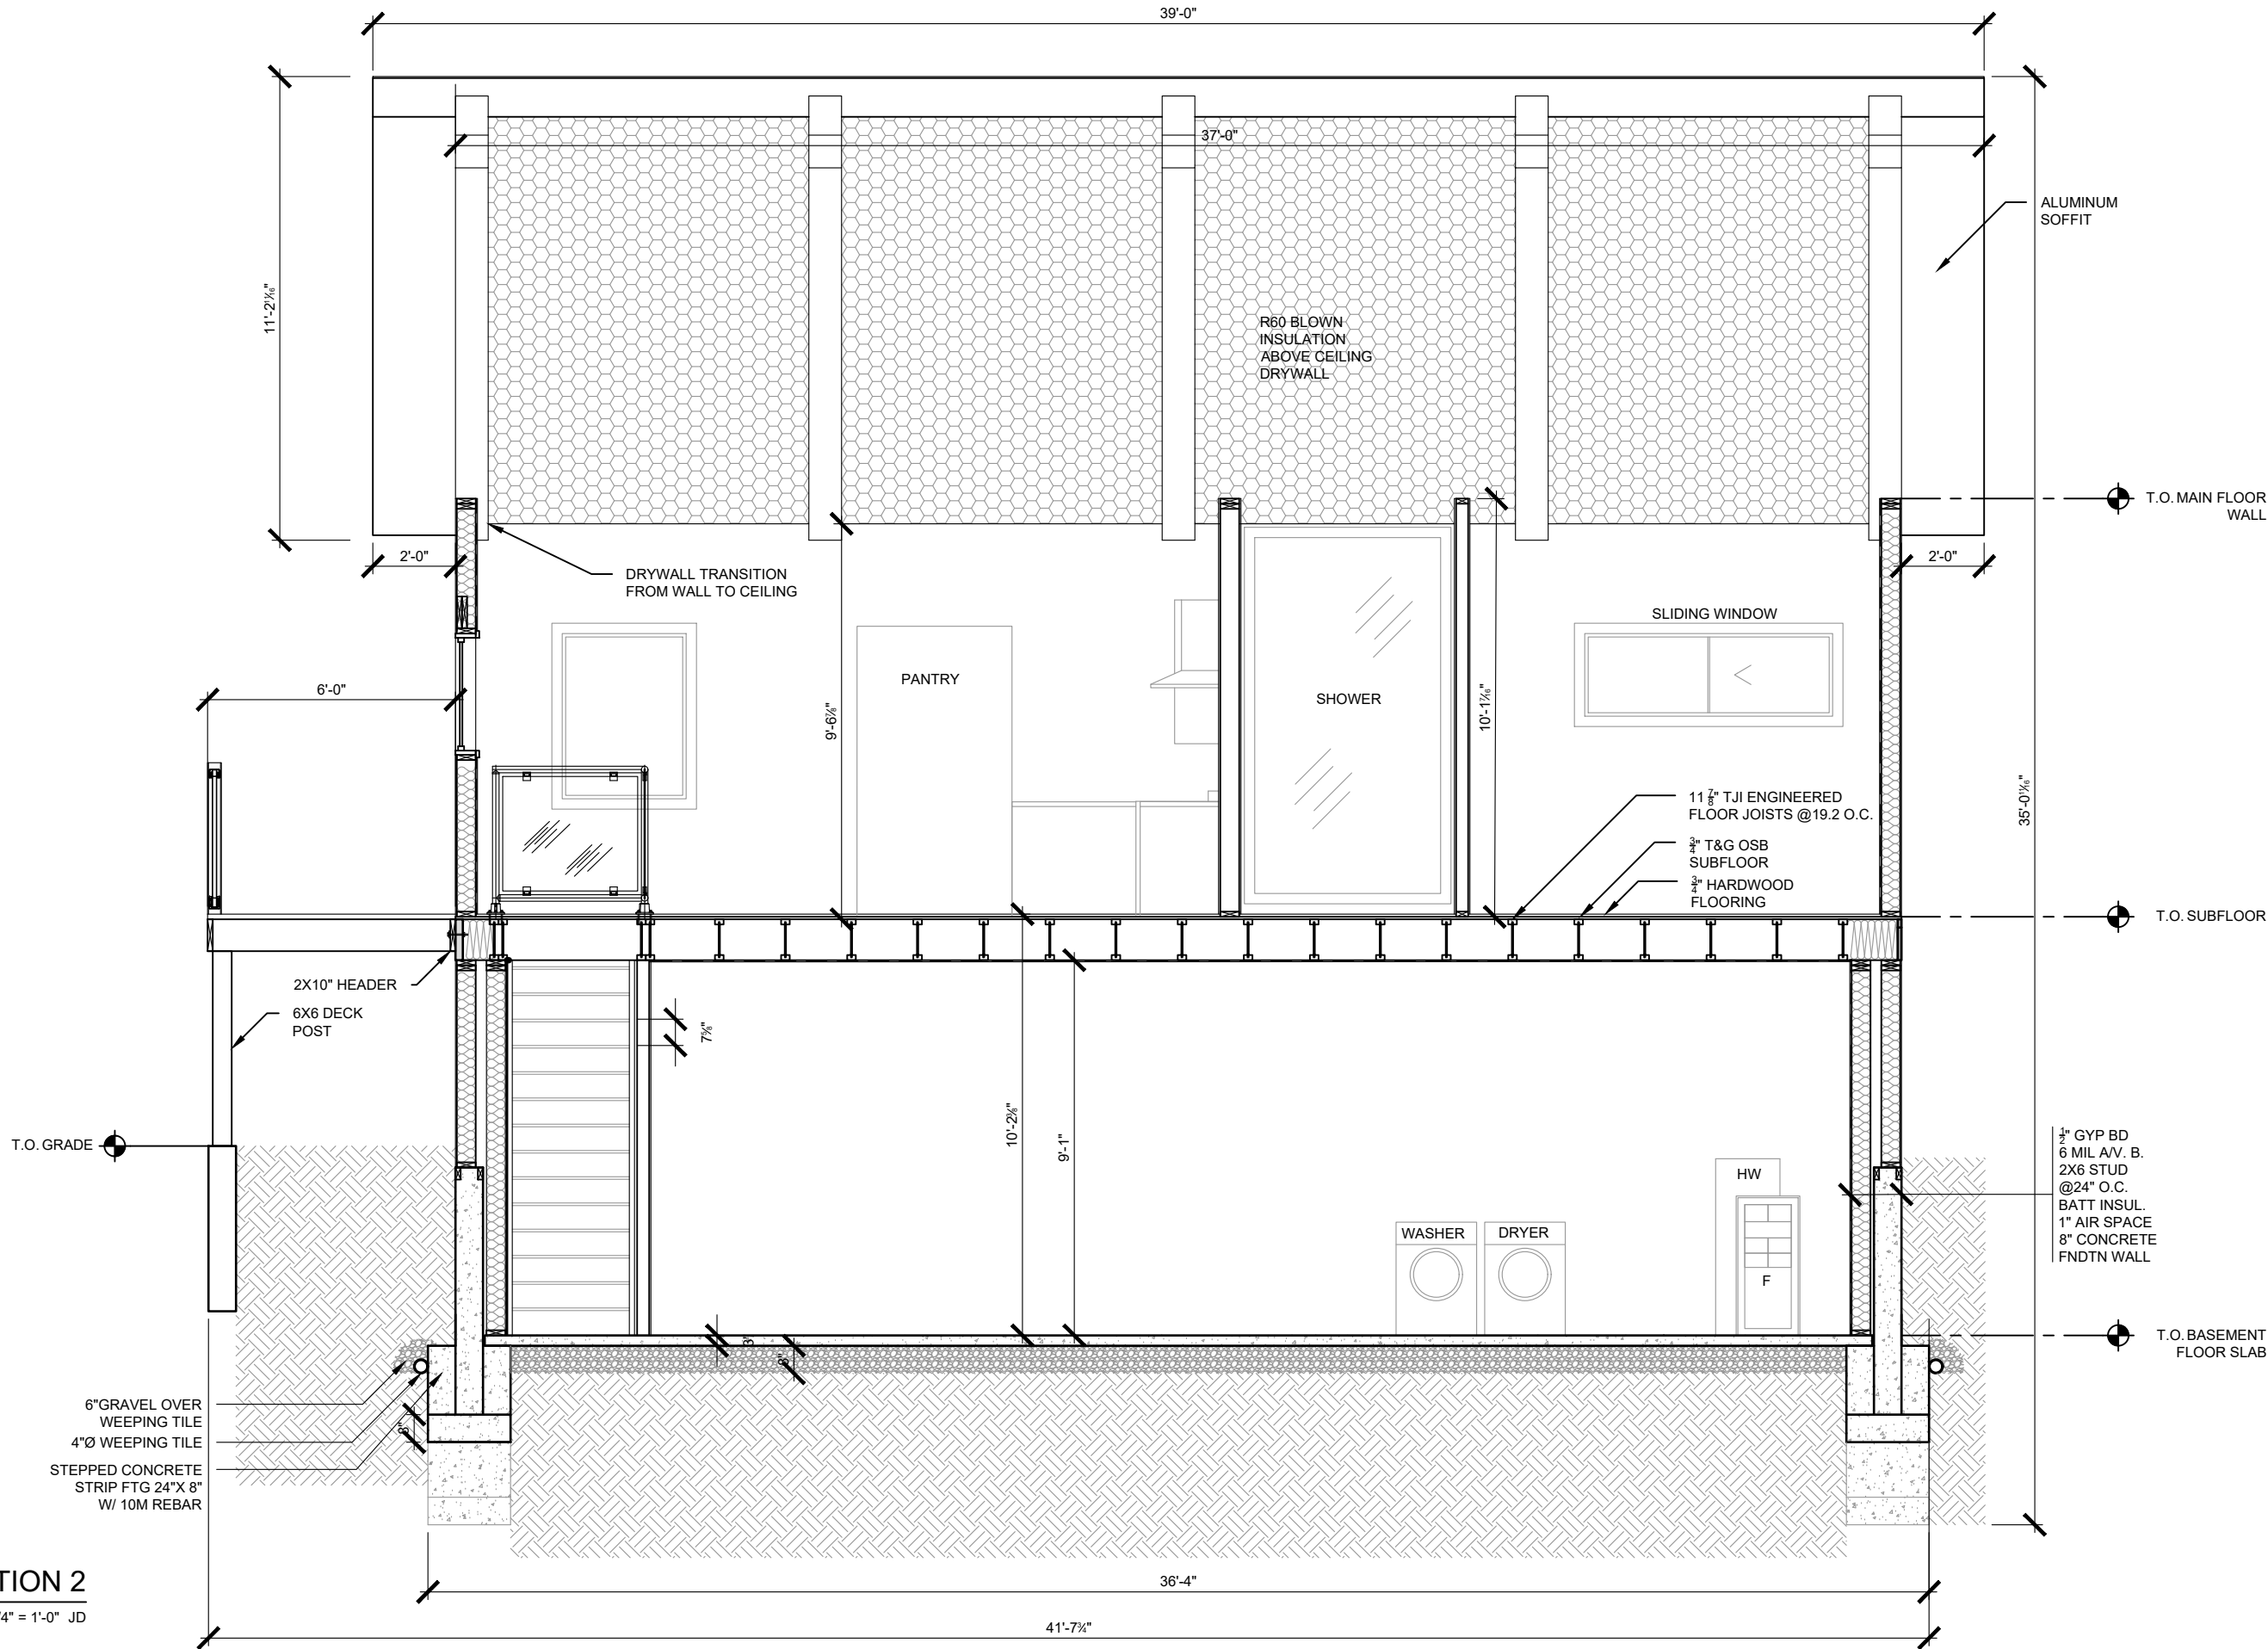

SECTION 2

SCALE 1/4" = 1'-0" JD

This drawing is the property of the SAIT.
The contractor shall check and verify all dimensions and report any discrepancies to the designers prior to construction.
Do not scale drawing.
This drawing is not to be used for construction unless it has been signed and approved.

Revisions:

Issued For:


Consultants/Seals:

Project:
**STUDIO HOUSE
PROJECT
ASSIGNMENT 9**

Drawing Name:
NORTH ELEVATION

Drawn: JD	Checked: LS
Date: 2018/04/19	
Drawing Scale: 1/4"=1'0"	

Project Number:	Sheet:
215-9	A7 OF 09
File Number: J DUNNING	

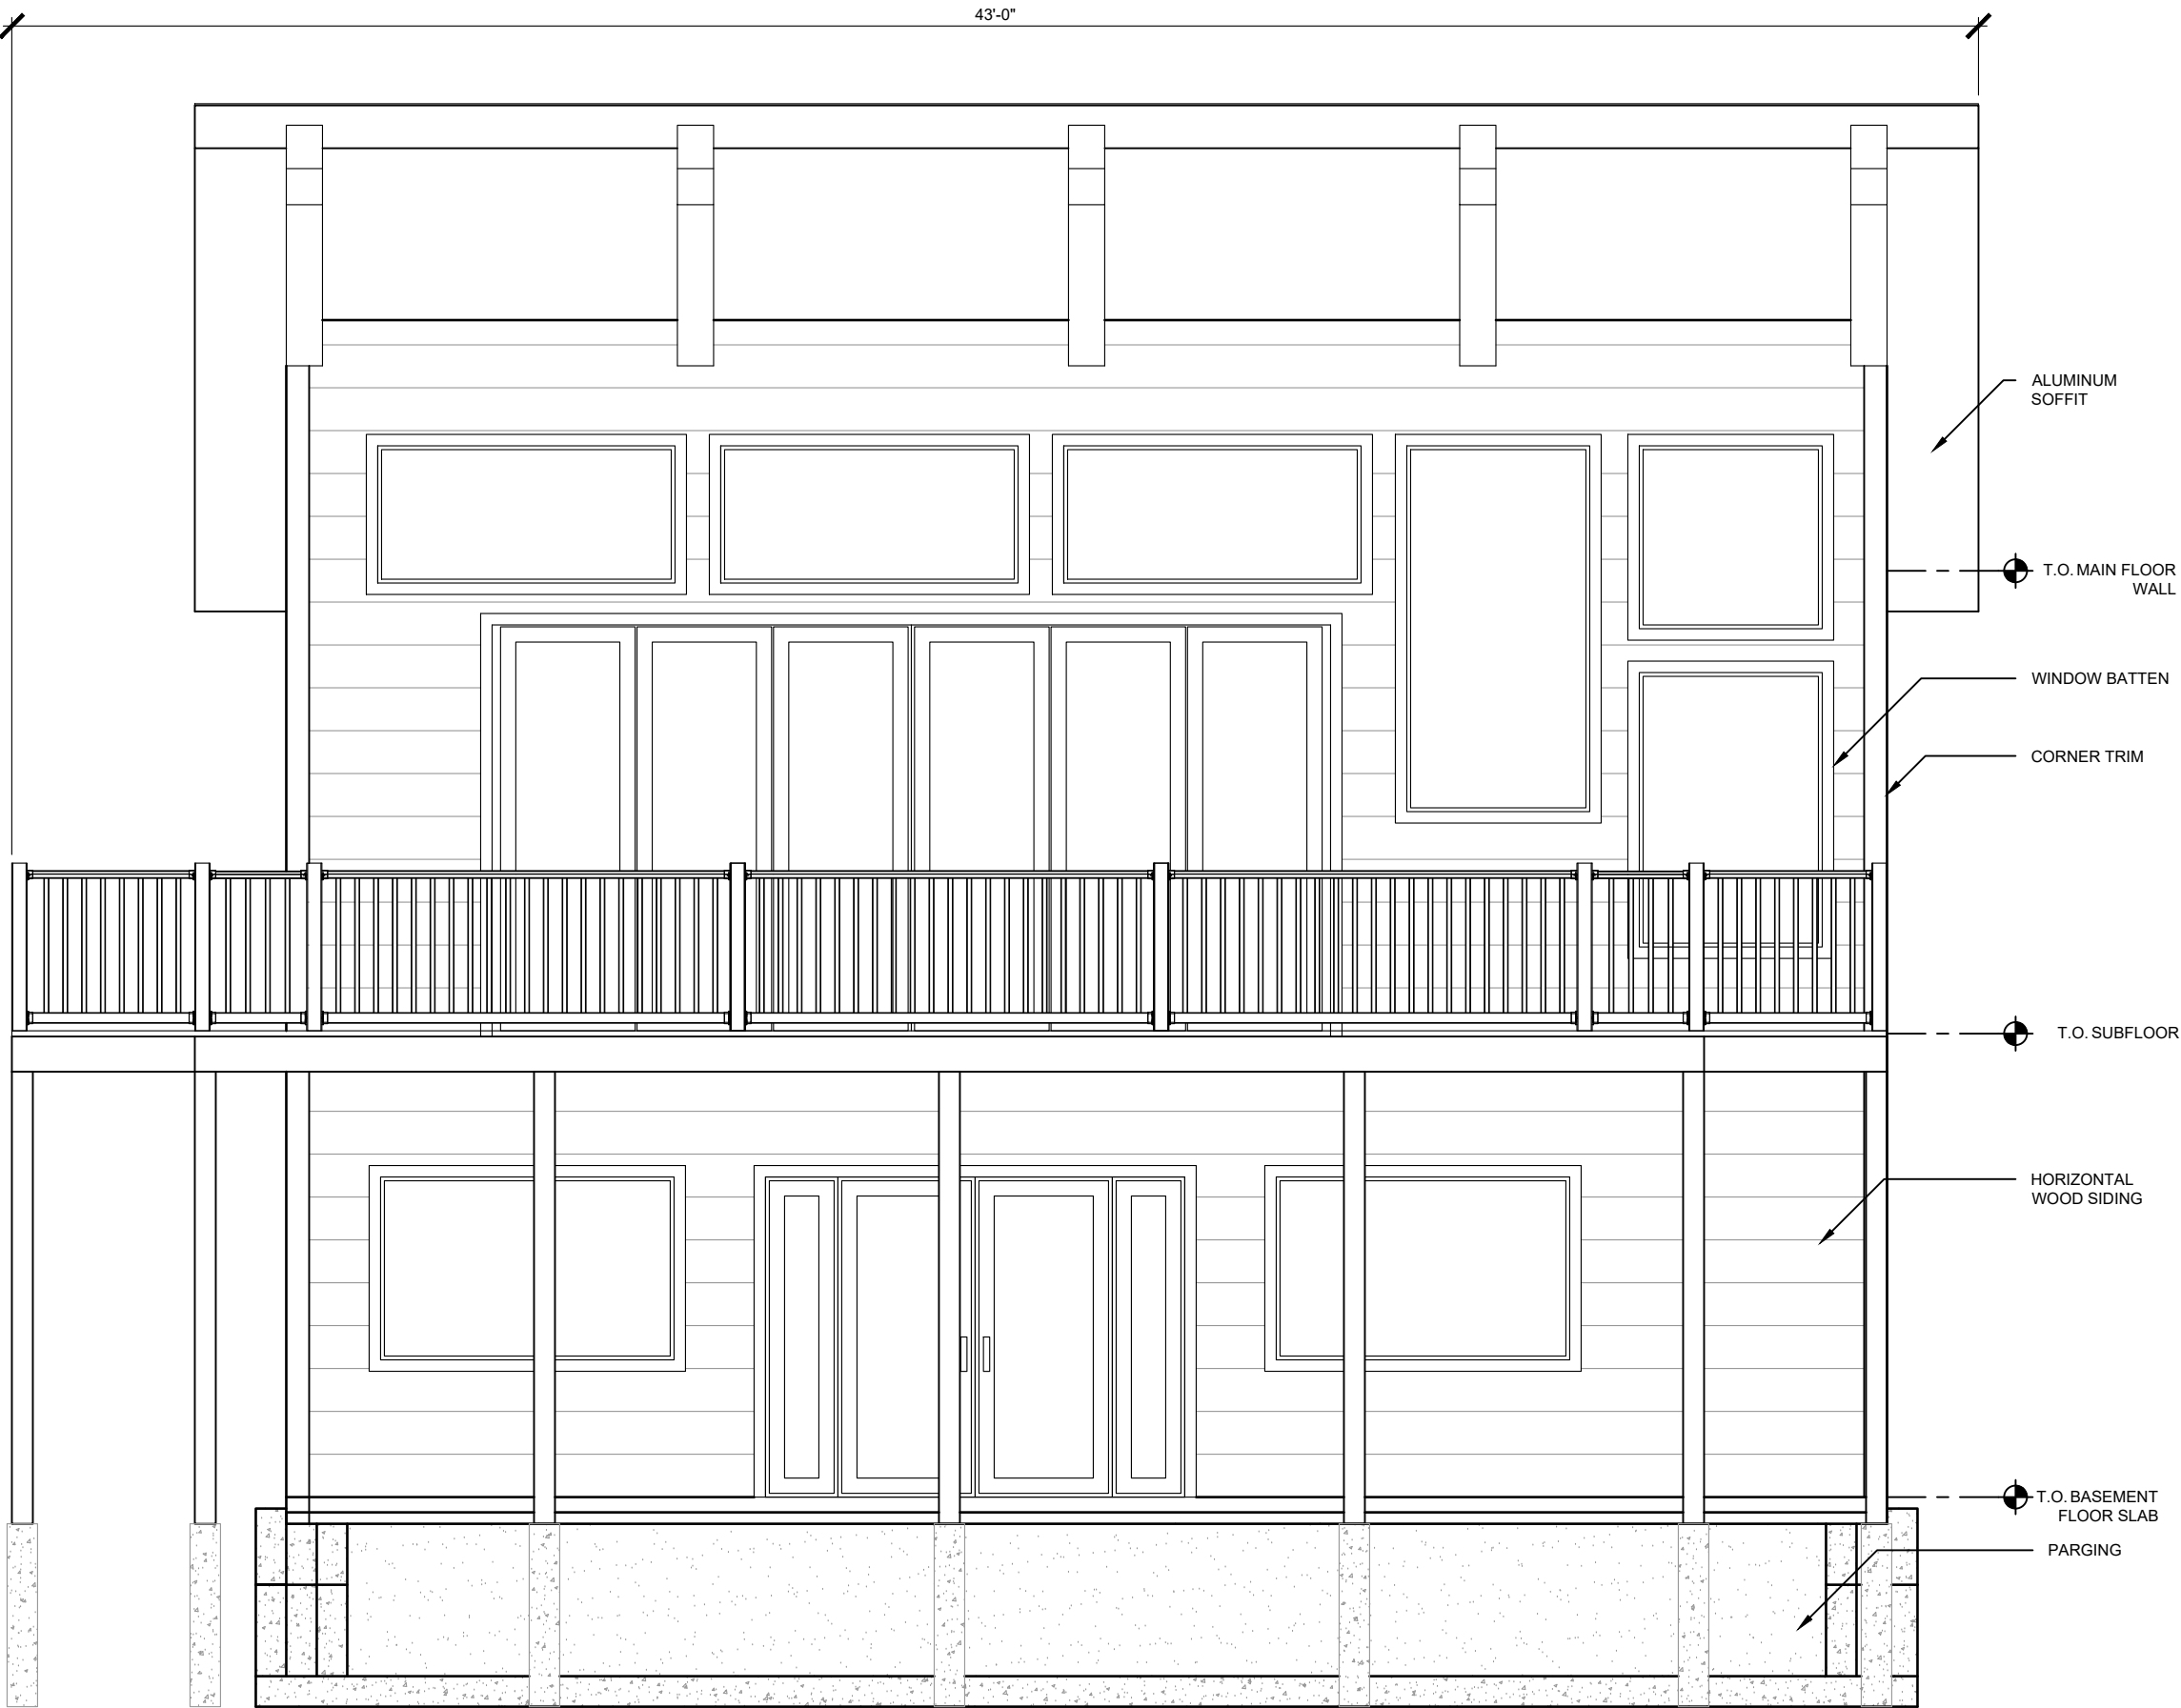

This drawing is the property of the SAIT.
The contractor shall check and verify all dimensions and report any discrepancies to the designers prior to construction. Do not scale drawing.
This drawing is not to be used for construction unless it has been signed and approved.

Revisions:

Issued For:


Consultants/Seals:

Project:
STUDIO HOUSE
PROJECT
ASSIGNMENT 9

Drawing Name:
SOUTH ELEVATION

Drawn: JD	Checked: LS
Date:	2018/04/19
Drawing Scale: 1/4"=1'0"	

Project Number:	Sheet:
215-9	A8 OF 10
File Number: J DUNNING	

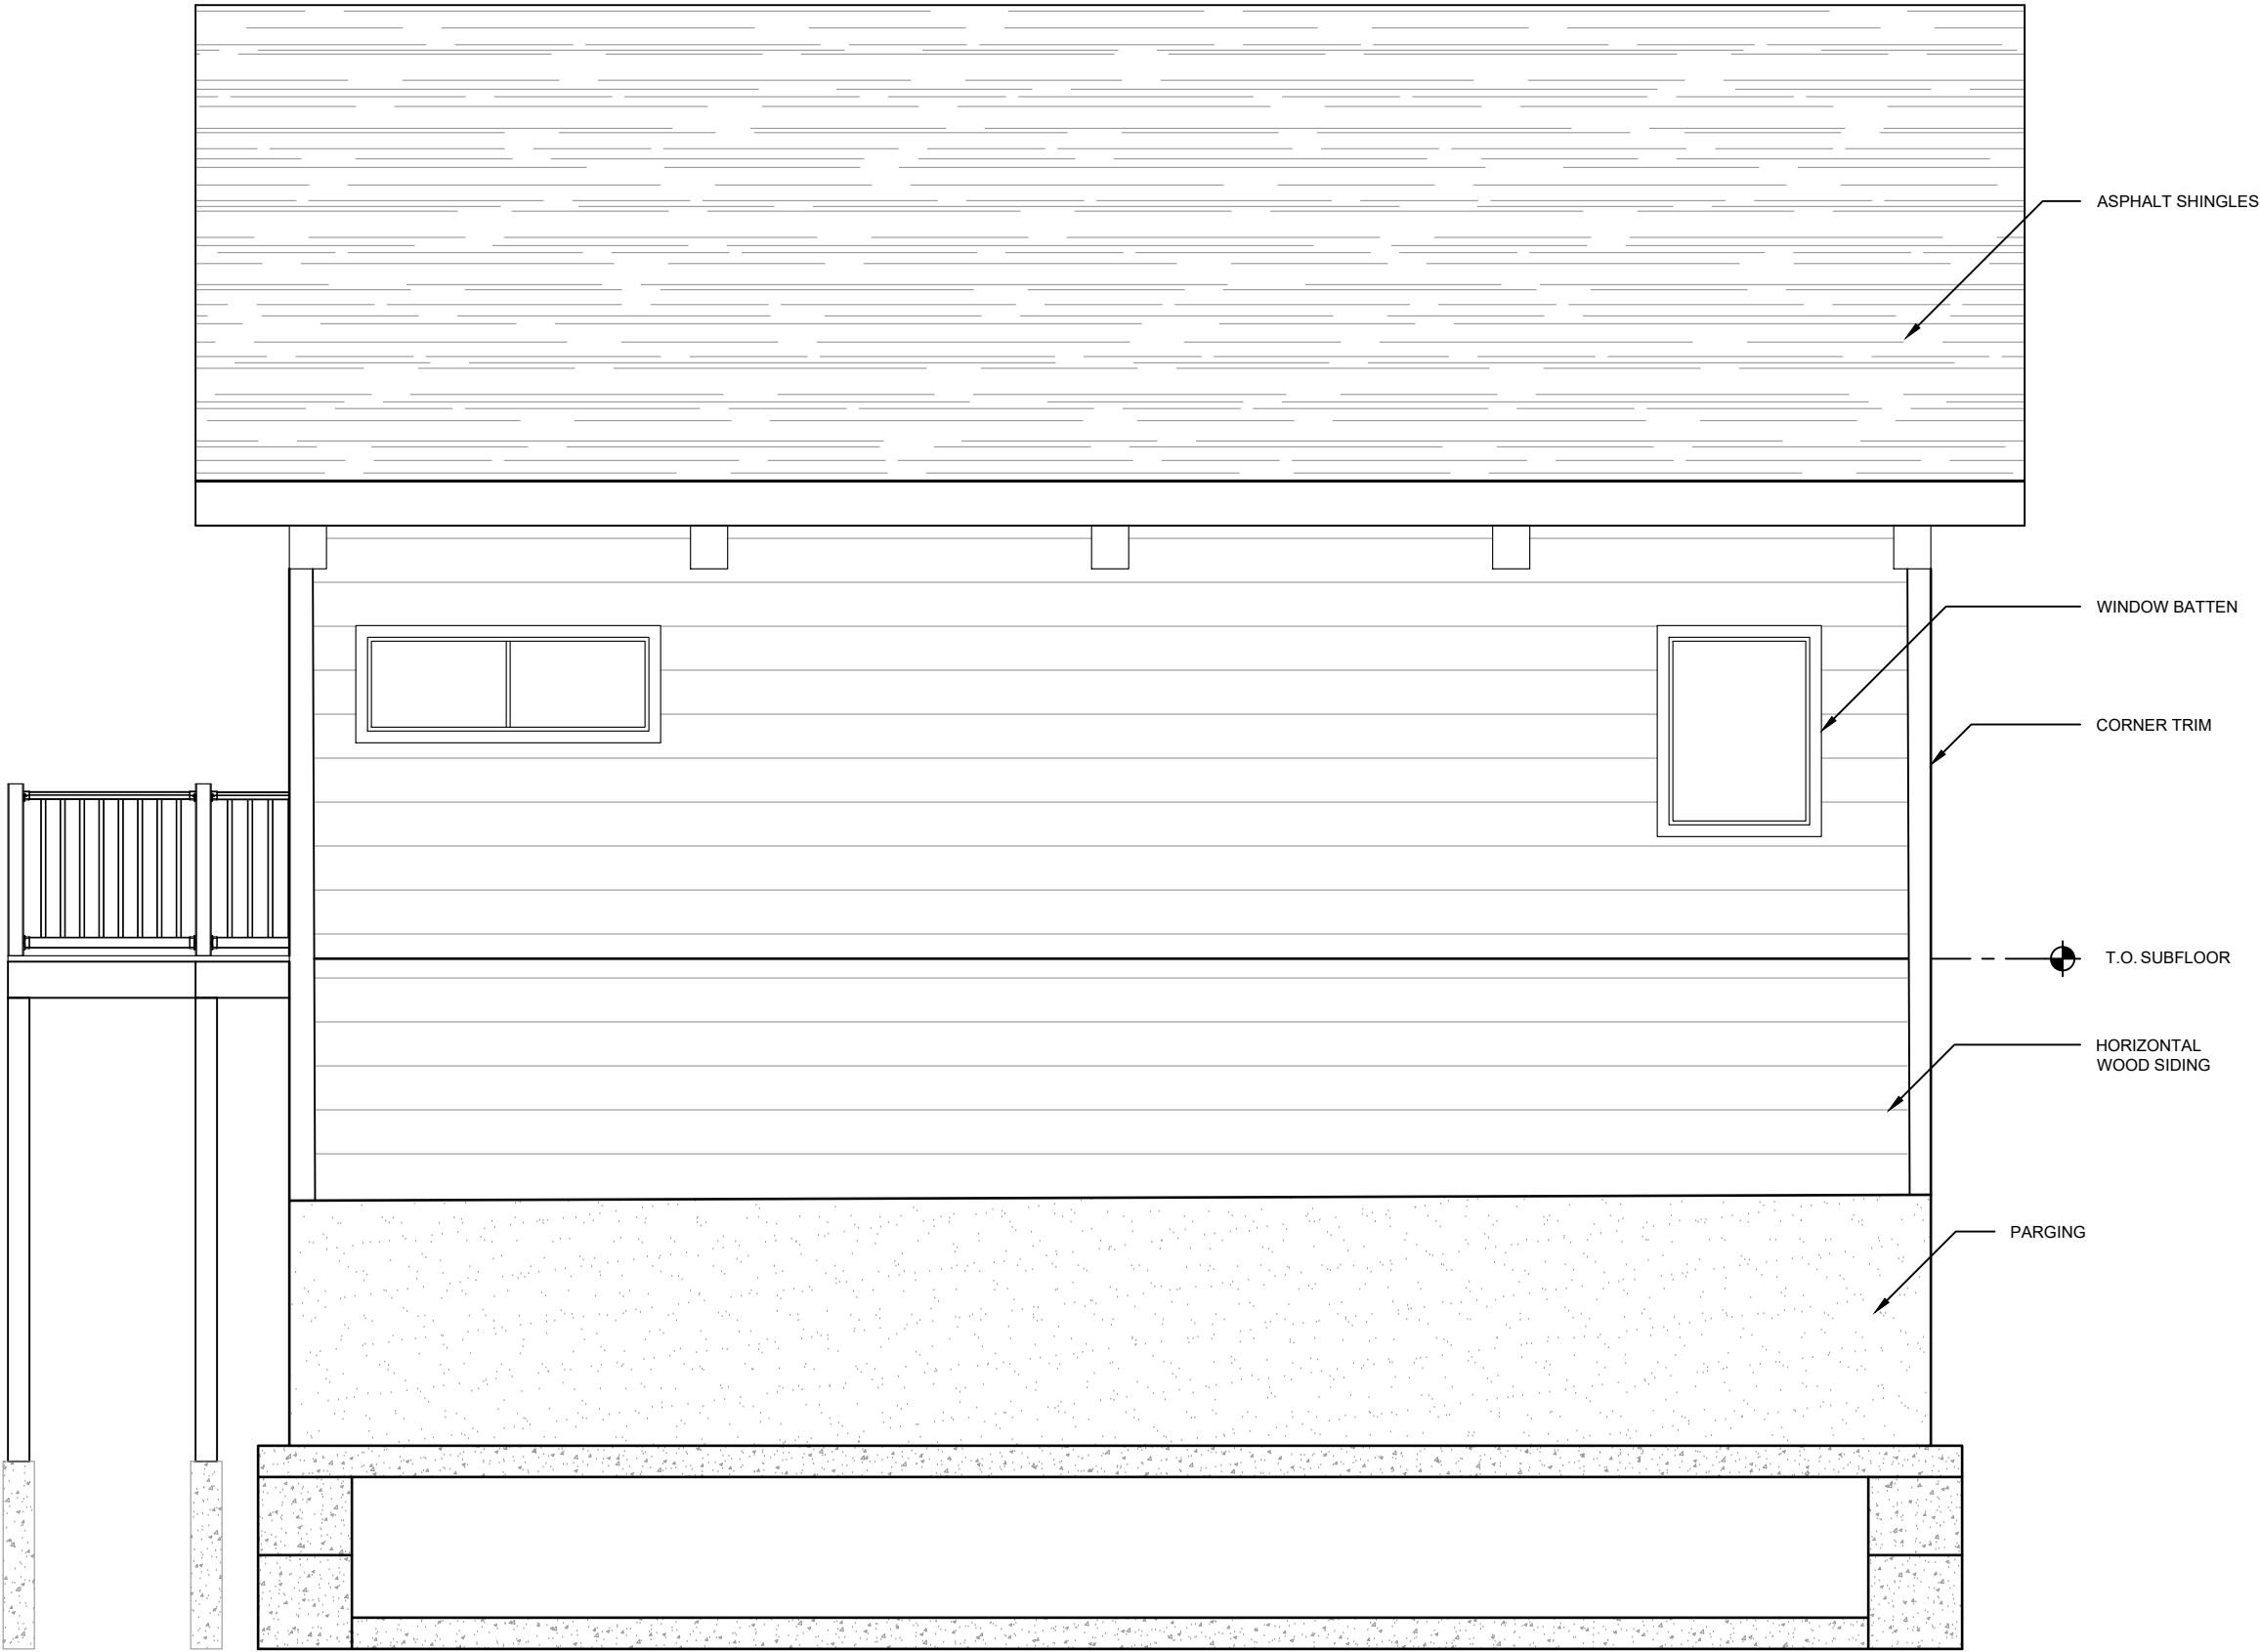

This drawing is the property of the SAIT.
The contractor shall check and verify all dimensions and report any discrepancies to the designers prior to construction.
Do not scale drawing.
This drawing is not to be used for construction unless it has been signed and approved.

Revisions:

Issued For:

Consultants/Seals:

Project:
**STUDIO HOUSE
PROJECT
ASSIGNMENT 9**

Drawing Name:
EAST ELEVATION

Drawn: JD Checked: LS


Date: 2018/04/19

Drawing Scale: 1/4"=1'0"

Project Number: Sheet:

215-9 A9_{OF10}

File Number: J DUNNING

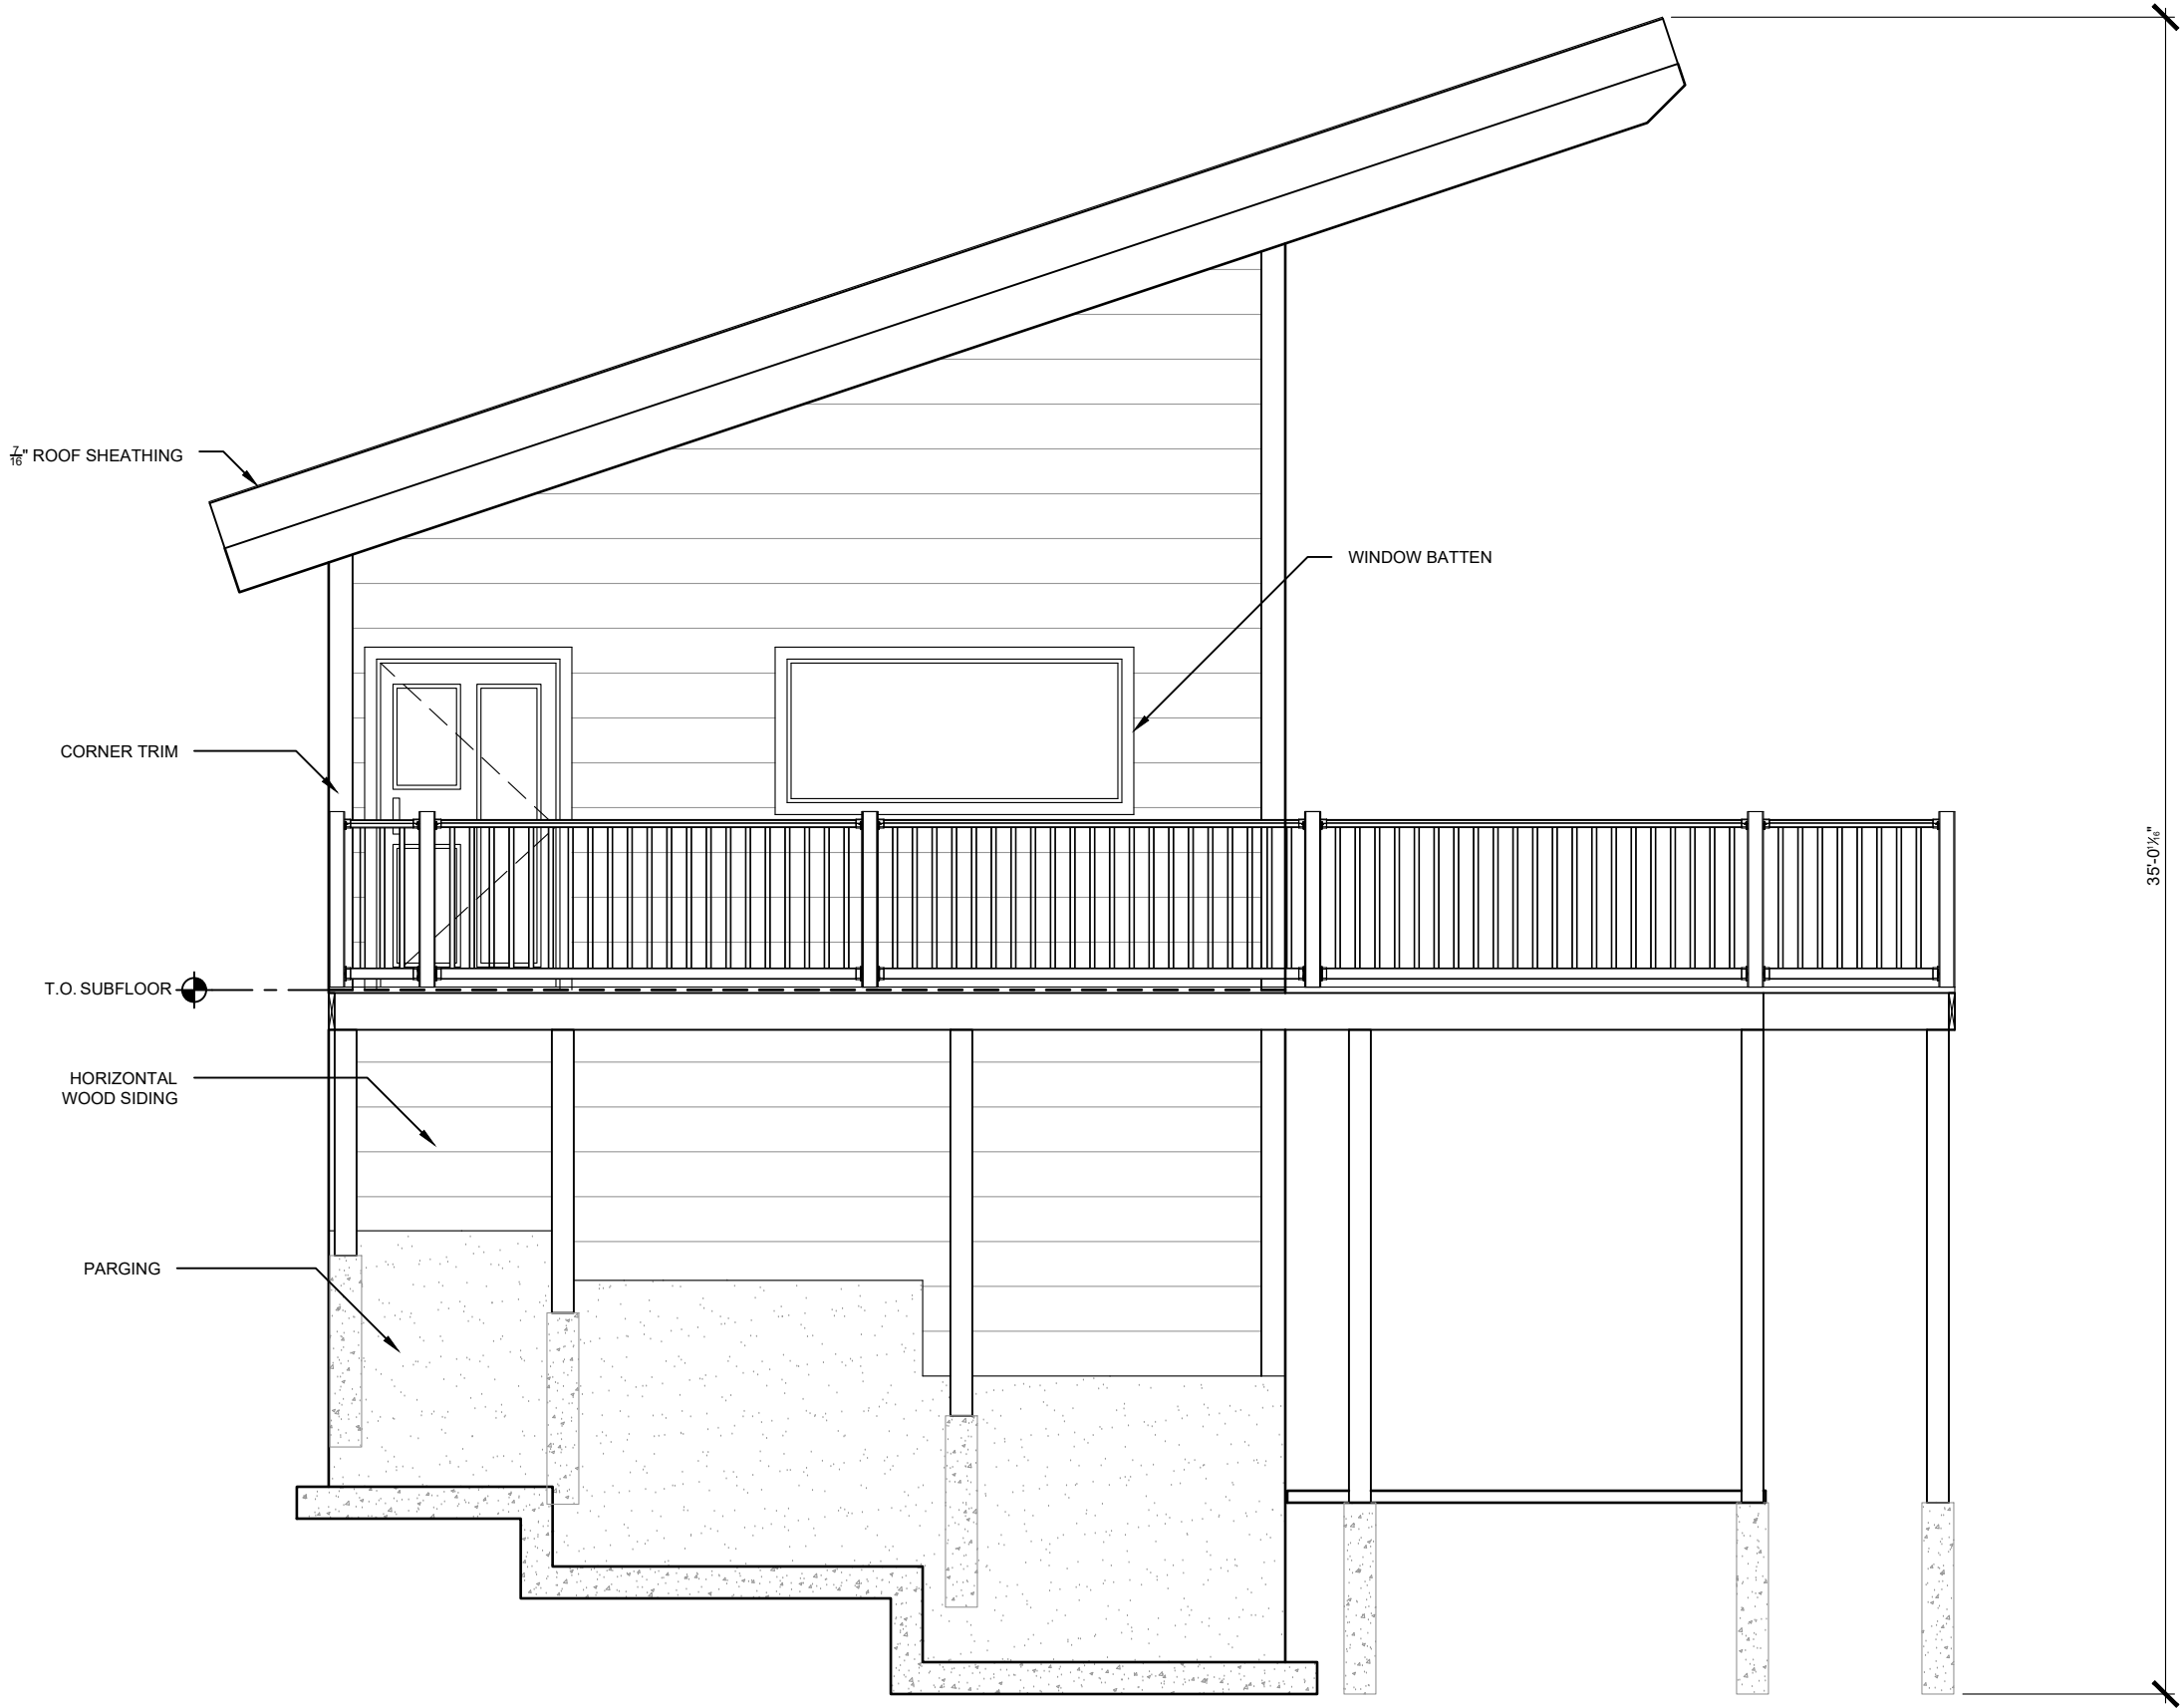

35'-0 1/4"

EAST ELEVATION

SCALE 1/4" = 1'-0"

JD

1

A9

This drawing is the property of the SAIT.
The contractor shall check and verify all dimensions and report any discrepancies to the designers prior to construction.
Do not scale drawing.
This drawing is not to be used for construction unless it has been signed and approved.

Revisions:

Issued For:

Consultants/Seals:

Project:
STUDIO HOUSE
PROJECT
ASSIGNMENT 9

Drawing Name:
WEST ELEVATION

Drawn: JD Checked: LS


Date: 2018/04/19

Drawing Scale: 1/4"=1'0"

Project Number: Sheet:

215-9 A10_D10

File Number: J DUNNING

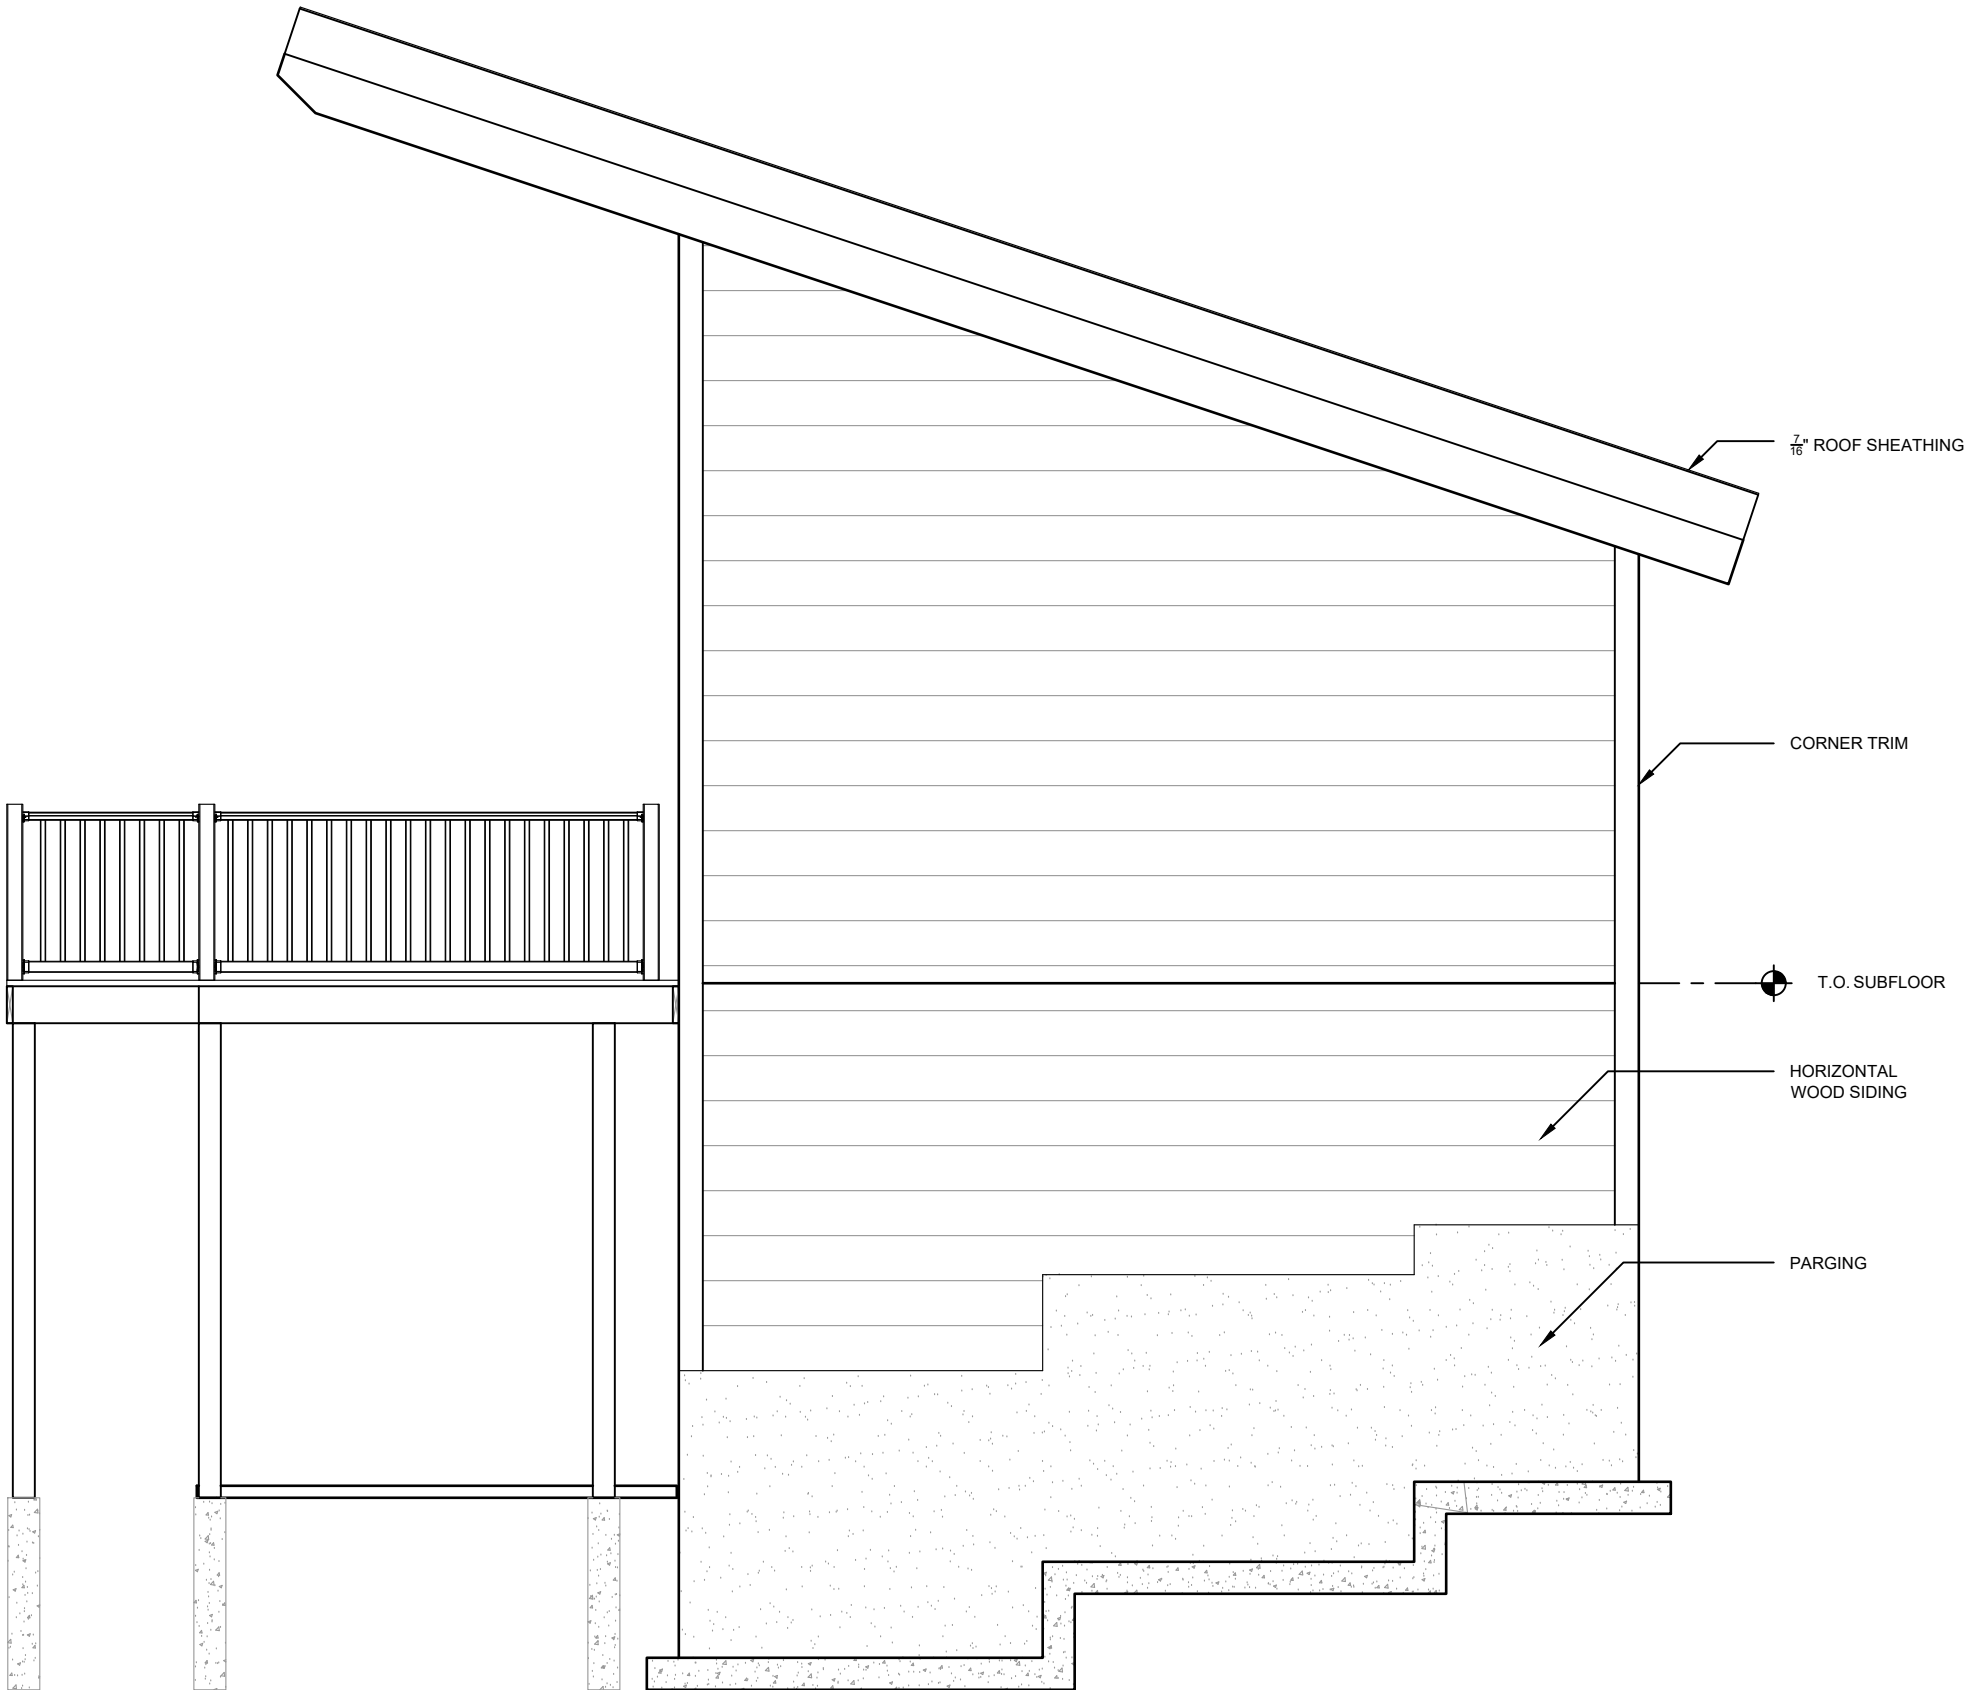


7/16" ROOF SHEATHING

CORNER TRIM

T.O. SUBFLOOR

HORIZONTAL
WOOD SIDING

PARGING

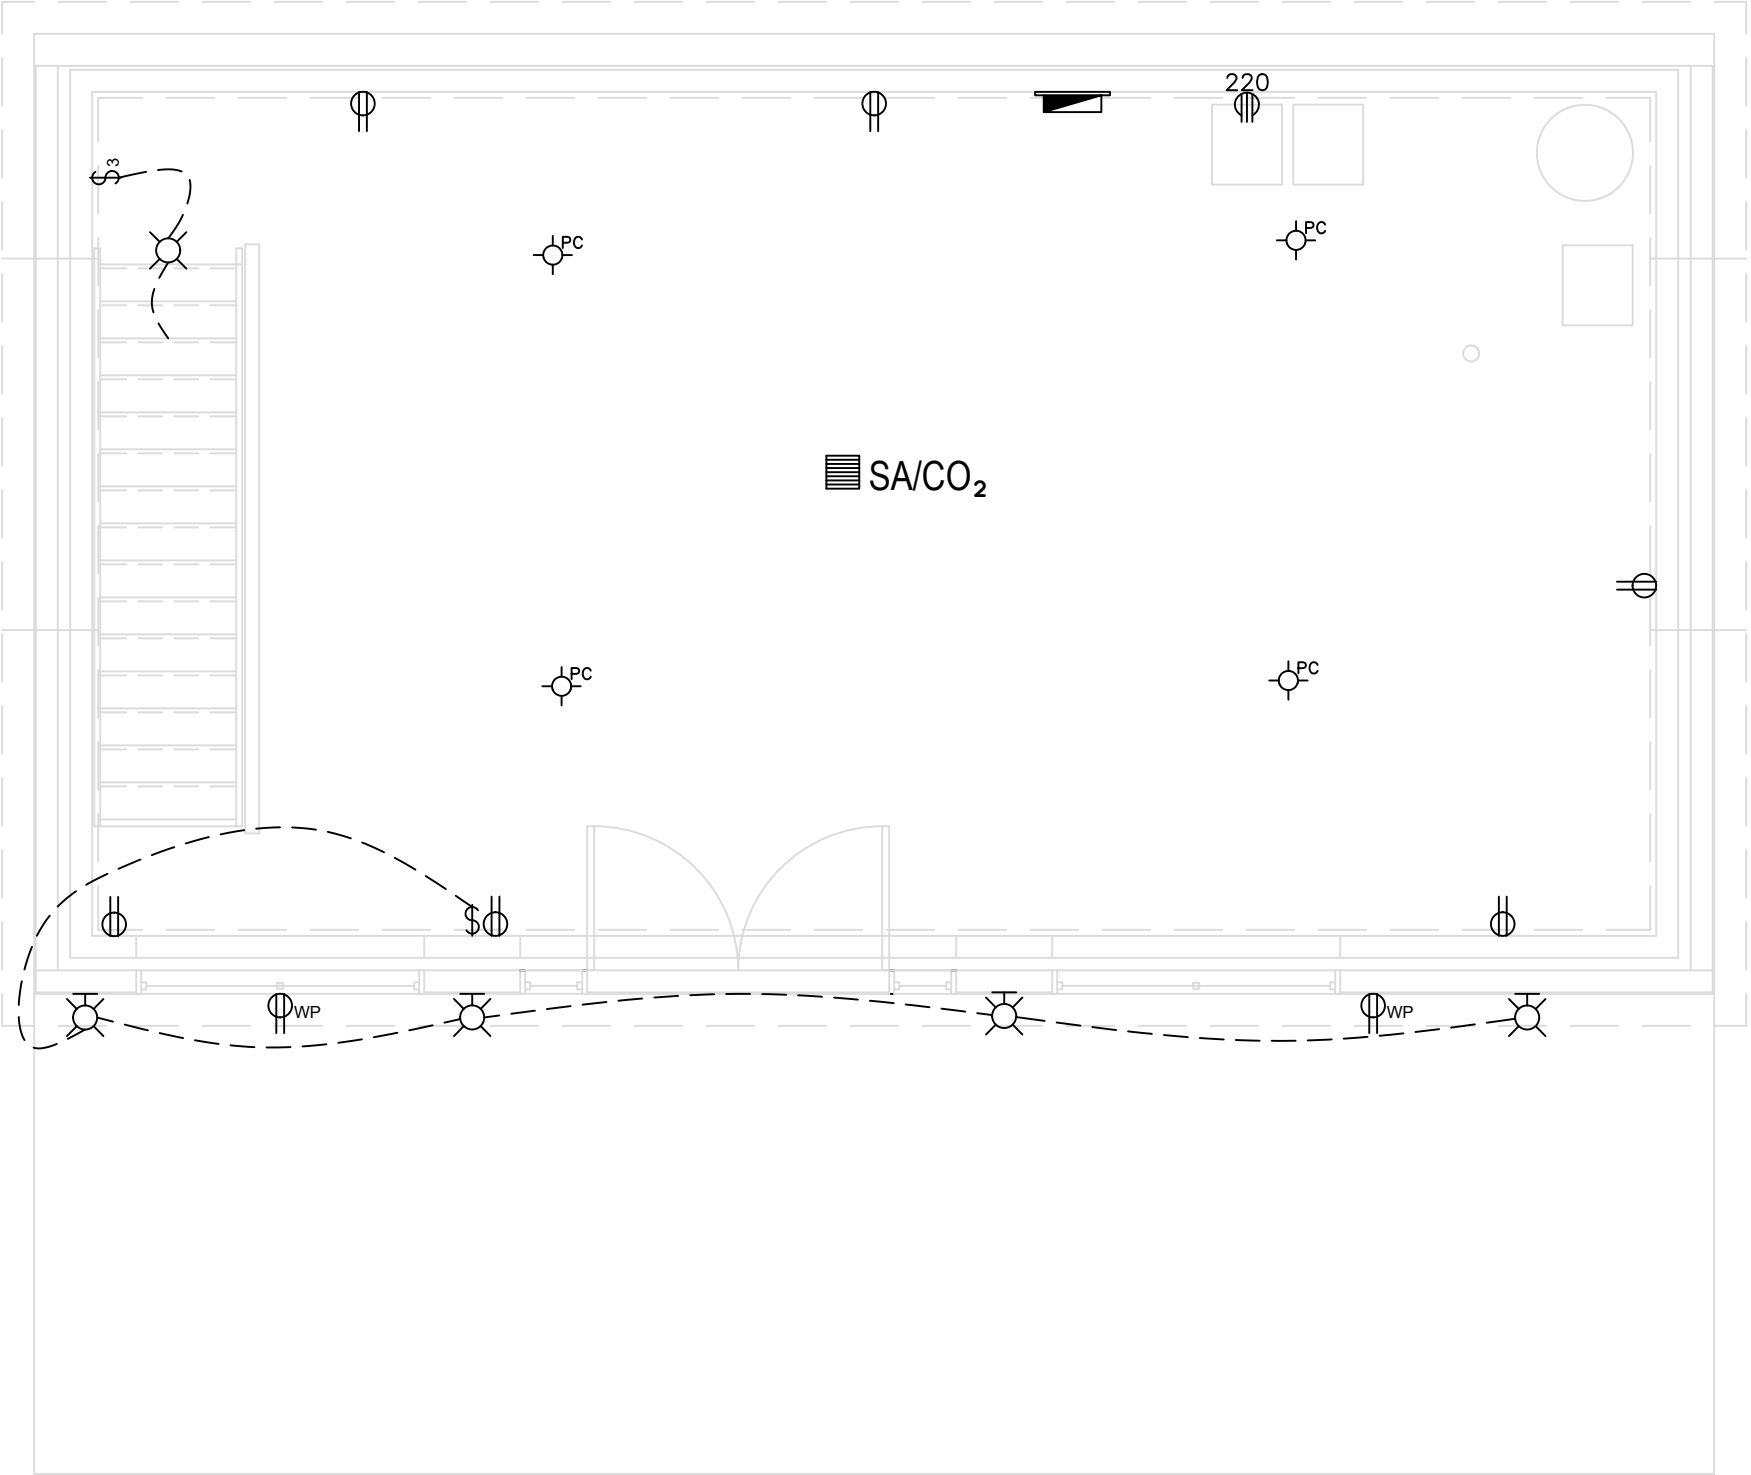

ELECTRICAL LEGEND	
SYMBOL	DESCRIPTION
\$	SINGLE POLE SWITCH
\$ ₃	3 WAY SWITCH
\$ _D	DIMMER SWITCH
\$ ₄	4 WAY SWITCH
⌚	DUPLEX RECEPTACLE 110V
⌚	SWITCHED OUTLET
⌚ _{WP}	WEATHER PROOF RECEPTACLE
⌚ _{GFI}	GROUND FAULT INTERRUPT RECEPTACLE
⌚ ₂₂₀	220V SPECIAL OUTLET
⌚ _{TV}	CABLE TV OUTLET
⌚ _{TEL}	TELEPHONE OUTLET
⌚ _T	FURNACE THERMOSTAT
⌚ _W	WALL MOUNTED LIGHT
⌚ _C	CEILING MOUNTED LIGHT
⌚ _P	PENDANT LIGHT
⌚ _{POT}	POT LIGHT
⌚ _{PC}	PULL CHAIN LIGHT
—○—○—	TRACK LIGHTING
⌚ _B	DOOR BELL
⌚ _{CH}	DOOR CHIME
⌚ _Δ	ELECTRICAL PANEL
⌚ _F	CEILING FAN
⌚ _{SA/CO₂}	SMOKE ALARM/CO2 ALARM
⌚ _B	BATHROOM FAN
⌚ _{zigzag}	UNDER CABINET LIGHT
⌚ _{DATA}	DATA OUTLET
---	ELECTRICAL WIRING

This drawing is the property of the SAIT.
The contractor shall check and verify all
dimensions and report any discrepancies
to the designers prior to construction.
Do not scale drawing.
This drawing is not to be used for
construction unless it has been signed
and approved.

Revisions:

Issued For:

Consultants/Seals:

Project:
STUDIO HOUSE
PROJECT
ASSIGNMENT 9

Drawing Name:
BASEMENT FLOOR
ELECTRICAL PLAN

Drawn: JD Checked: LS

Date: 2018/04/19

Drawing Scale: 1/4"=1'0"

Project Number: Sheet:

215-9 E1 OF 2

File Number: J DUNNING

This drawing is the property of the SAIT.
The contractor shall check and verify all
dimensions and report any discrepancies
to the designers prior to construction.
Do not scale drawing.
This drawing is not to be used for
construction unless it has been signed
and approved.

Revisions:

Issued For:

Consultants/Seals:

Project:
STUDIO HOUSE
PROJECT
ASSIGNMENT 9

Drawing Name:
MAIN FLOOR
ELECTRICAL PLAN

Drawn: JD Checked: LS

Date: 2018/04/19

Drawing Scale: 1/4"=1'0"

Project Number: Sheet:

215-9 E2 OF 2

File Number: J DUNNING

